



CAD FILE 3591-01BMB1	PLOTTING SCALE 1 = 1	SHEET NO. B1	JOB NO. 3591-01
DRAWN PSK	DATE 02/19/24	REVISION	
CHECKED BNB	DATE 02/19/24	PHASE-1	

QTY. RECIEVED	ITEM	QTY.	MARK	DESCRIPTION Title Packing List	LENGTH
	1			BUILT UP SHOP	
	2			FINISH:BLACK; SPECIAL PAINT BY OTHERS	
	3			(FLAT WHITE FSC #37875)	
	4				
	5	ONE	01RFI-1	COLUMN(S)	37'-4 1/2"
	6	2	02RFI-2	RAFTER(S)	33'-1 3/8"
	7	2	03RFI-3	RAFTER(S)	33'-1 3/8"
	8	ONE	04RFI-4	COLUMN(S)	37'-4 1/2"
	9	ONE	05RFI-5	COLUMN(S)	37'-4 1/2"
	10	ONE	06RFI-6	COLUMN(S)	37'-4 1/2"
	11	ONE	07RFI-7	COLUMN(S)	37'-4 1/2"
	12	ONE	07RFI-7A	COLUMN(S)	37'-4 1/2"
	13	2	08RFI-8	RAFTER(S)	33'-1 3/8"
	14	2	09RFI-9	RAFTER(S)	33'-1 3/8"
	15	2	10RFI-10	RAFTER(S)	33'-1 3/8"
	16	ONE	11RFI-11	COLUMN(S)	37'-4 1/2"
	17	2	12RFI-12	COLUMN(S)	37'-4 1/2"
	18	ONE	12RFI-12A	COLUMN(S)	37'-4 1/2"
	19				
	20				
	21				
	22				
	23			ROOF LN. A LN. D LN. I LN. S PART	
	24		K101	JAMB/GIRT SLOTTED CLIP(S) (P 1/8" x 6") x	0'-8 3/4"
	25		K102	JAMB/GIRT SLOTTED CLIP(S) (P 1/8" x 6") x	0'-9 3/4"
	26		K107	BASE CLIP(S) (P 1/8" x 6") x	0'-9 3/4"
	27				



CAD FILE	3591-01BMB2	PLOTTING SCALE	1 = 1	SHEET NO.	B2	JOB NO.	3591-01
DRAWN	MLR	DATE	03/18/24	REVISION			
CHECKED	VR	DATE	03/19/24	PHASE-II			

QTY. RECIEVED	ITEM	QTY.	MARK	DESCRIPTION Title Packing List	LENGTH
	1			BUILT UP SHOP	
	2			FINISH: RED OXIDE	
	3				
	4				
	5				
	6				
	7				
	8				
	9				
	10				
	11				
	12				
	13				
	14				
	15				
	16				
	17				
	18				
	19				
	20				
	21				
	22				
	23			ROOF LN. D LN. 5 LN. A LN. I PART	
	24 (+1)	5	K101	JAMB/GIRT SLOTTED CLIP(S) (1/8" x 6") x	0'-8 3/4"
	25 (+8)	180	K102	JAMB/GIRT SLOTTED CLIP(S) (1/8" x 6") x	0'-9 3/4"
	26 (+1)	7	K107	BASE CLIP(S) (1/8" x 6") x	0'-9 3/4"
	27				



CAD FILE
3591-01BMB3


PLOTTING SCALE
1 = 1

SHEET NO.
B3

JOB NO.
3591-01

DRAWN
MLR


DATE
03/18/24

REVISION  1 05/01/42 - VR

CHECKED
VR

DATE
03/19/24

PHASE-III

QTY. RECIEVED	ITEM	QTY.	MARK	DESCRIPTION Title Packing List	LENGTH
	1			BUILT UP SHOP	
	2			FINISH: PRE-GALV. 	
	3				
	4				
	5				
	6				
	7	14	97PLI	SHEETING PLATE(S) (PL 14GA x 12") x	1'-7"
	8				
	9				
	10				
	11				
	12				
	13				
	14				
	15				
	16				
	17				
	18				
	19				
	20				
	21				
	22				
	23				
	24		K101	JAMB/GIRT SLOTTED CLIP(S) (PL 1/8" x 6") x	0'-8 3/4"
	25		K102	JAMB/GIRT SLOTTED CLIP(S) (PL 1/8" x 6") x	0'-9 3/4"
	26		K107	BASE CLIP(S) (PL 1/8" x 6") x	0'-9 3/4"
	27				



CAD FILE 3591-01BMB4	PLOTTING SCALE 1 = 1	SHEET NO. B4	JOB NO. 3591-01
DRAWN PSK	DATE 02/19/24	REVISION	
CHECKED BNB	DATE 02/19/24	PHASE-II	

QTY. RECIEVED	ITEM	QTY.	MARK	DESCRIPTION Title Packing List	LENGTH
	1			NCI STD. CLIPS - BUILT UP SHOP	
	2			FINISH: RED OXIDE	
	3				
	4		SC-10	M.F. TO COLD FORMED E.W. COLUMN CLIP (BNT. $\text{PL } 10 \text{ GA} \times 6''$) x	0'-8 $\frac{3}{4}''$
	5		SC-20	M.F. TO COLD FORMED E.W. COLUMN CLIP (BNT. $\text{PL } 10 \text{ GA} \times 6''$) x	2'-1''
	6		SC-80	M.F. TO ENDWALL COLUMN CLIP (BNT. $\text{PL } 10 \text{ GA} \times 6''$) x	2'-1''
	7				
	8		SC-17	EAVE STRUT STIFFENER PLATE ($\text{PL } \frac{3}{16}'' \times 2''$) x	1'-9 $\frac{1}{2}''$
	9				
	10		SC-22	LINER FLANGE BRACE CLIP AT 8" MEMBER ($\text{PL } \frac{3}{16}'' \times 2''$) x	0'-11''
	11		SC-77	LINER FLANGE BRACE CLIP AT 10" MEMBER ($\text{PL } \frac{3}{16}'' \times 2''$) x	0'-11 $\frac{1}{2}''$
	12		SC-78	LINER FLANGE BRACE CLIP AT 12" MEMBER ($\text{PL } \frac{3}{16}'' \times 2''$) x	1'-0 $\frac{1}{2}''$
	13				
	14 (+2)	26	SC-58	M.F. CORNER COLUMN GIRT CLIP AT 8" MEMBER ($\text{PL } 10 \text{ GA} \times 8 \frac{1}{2}''$) x	1'-4 $\frac{3}{4}''$
	15		SC-59	M.F. CORNER COLUMN GIRT CLIP AT 10" MEMBER ($\text{PL } 10 \text{ GA} \times 9 \frac{1}{2}''$) x	1'-4 $\frac{3}{4}''$
	16		SC-60	M.F. CORNER COLUMN GIRT CLIP AT 12" MEMBER ($\text{PL } 10 \text{ GA} \times 10 \frac{1}{2}''$) x	1'-4 $\frac{3}{4}''$
	17				
	18		SC-97	E/W COLUMN CLIP (@1'-3" FOR W8 FLUSH FRAME) ($\text{PL } 10 \text{ GA} \times 6''$) x	1'-11''
	19				
	20				
	21				
	22				
	23				
	24				
	25				
	26				
	27				



CAD FILE 3591-01BMB5	PLOTTING SCALE 1 = 1	SHEET NO. B5	JOB NO. 3591-01
DRAWN PSK	DATE 02/19/24	REVISION	
CHECKED BNB	DATE 02/19/24	PHASE-I	


QTY. RECIEVED	ITEM	QTY.	MARK	DESCRIPTION Title Packing List	LENGTH
	1			NCI STD. CLIPS - BUILT UP SHOP	
	2			FINISH:BLACK; SPECIAL PAINT BY OTHERS	
	3			(FLAT WHITE FSC #37875)	
	4				
	5		SC-10	M.F. TO COLD FORMED E.W. COLUMN CLIP (BNT. $\text{PL } 10 \text{ GA} \times 6''$) \times	0'-8 $\frac{3}{4}''$
	6		SC-20	M.F. TO COLD FORMED E.W. COLUMN CLIP (BNT. $\text{PL } 10 \text{ GA} \times 6''$) \times	2'-1''
	7		SC-80	M.F. TO ENDWALL COLUMN CLIP (BNT. $\text{PL } 10 \text{ GA} \times 6''$) \times	2'-1''
	8				
	9		SC-17	EAVE STRUT STIFFENER PLATE ($\text{PL } \frac{3}{16}'' \times 2''$) \times	1'-9 $\frac{1}{2}''$
	10				
	11 (+4)	100	SC-22	LINER FLANGE BRACE CLIP AT 8" MEMBER ($\text{PL } \frac{3}{16}'' \times 2''$) \times	0'-11''
	12		SC-77	LINER FLANGE BRACE CLIP AT 10" MEMBER ($\text{PL } \frac{3}{16}'' \times 2''$) \times	0'-11 $\frac{1}{2}''$
	13		SC-78	LINER FLANGE BRACE CLIP AT 12" MEMBER ($\text{PL } \frac{3}{16}'' \times 2''$) \times	1'-0 $\frac{1}{2}''$
	14				
	15		SC-58	M.F. CORNER COLUMN GIRT CLIP AT 8" MEMBER ($\text{PL } 10 \text{ GA} \times 8 \frac{1}{2}''$) \times	1'-4 $\frac{3}{4}''$
	16		SC-59	M.F. CORNER COLUMN GIRT CLIP AT 10" MEMBER ($\text{PL } 10 \text{ GA} \times 9 \frac{1}{2}''$) \times	1'-4 $\frac{3}{4}''$
	17		SC-60	M.F. CORNER COLUMN GIRT CLIP AT 12" MEMBER ($\text{PL } 10 \text{ GA} \times 10 \frac{1}{2}''$) \times	1'-4 $\frac{3}{4}''$
	18				
	19		SC-97	E/W COLUMN CLIP (@1'-3" FOR W8 FLUSH FRAME) ($\text{PL } 10 \text{ GA} \times 6''$) \times	1'-11''
	20				
	21				
	22				
	23				
	24				
	25				
	26				
	27				



CAD FILE 3591-01BMC1	PLOTTING SCALE 1 = 1	SHEET NO. C1	JOB NO. 3591-01
DRAWN MLR	DATE 03/18/24	REVISION	
CHECKED VR	DATE 03/19/24	PHASE-1	

QTY. RECIEVED	ITEM	QTY.	MARK	DESCRIPTION Title Packing List	LENGTH
	1			HOT ROLL SHOP	
	2			FINISH: BLACK; SPECIAL PAINT BY OTHERS	
	3			(FLAT WHITE FSC #37875)	
	4				
	5	8	13WC1	WIND BENT COLUMN(S) (W14 x 38 x 25'-11 1/2") x	26'-0"
	6				
	7	2	15WR1	WIND BENT RAFTER(S) (W14 x 30 x 16'-10") x	16'-11 1/4"
	8	2	16WR1	WIND BENT RAFTER(S) (W14 x 30 x 14'-10") x	14'-11 1/4"
	9				
	10	ONE	17EC1	ENDWALL COLUMN(S) (W14 x 38 x 40'-8 15/16") x	40'-9 5/16"
	11	ONE	18EC1	ENDWALL COLUMN(S) (W14 x 38 x 42'-4 15/16") x	42'-5 5/16"
	12	ONE	19EC1	ENDWALL COLUMN(S) (W14 x 38 x 40'-8 15/16") x	40'-9 5/16"
	13	ONE	20EC1	ENDWALL COLUMN(S) (W14 x 38 x 42'-4 15/16") x	42'-5 5/16"
	14				
	15	ONE	28CB1	CRANE BEAM(S) (W24x55/C10x15.3) x	18'-6"
	16	ONE	29CB1	CRANE BEAM(S) (W24x55/C10x15.3) x	22'-6"
	17	ONE	30CB1	CRANE BEAM(S) (W24x55/C10x15.3) x	20'-6"
	18	ONE	31CB1	CRANE BEAM(S) (W24x55/C10x15.3) x	20'-6"
	19	ONE	32CB1	CRANE BEAM(S) (W24x55/C10x15.3) x	18'-6"
	20	ONE	33CB1	CRANE BEAM(S) (W24x55/C10x15.3) x	22'-6"
	21	ONE	34CB1	CRANE BEAM(S) (W24x55/C10x15.3) x	20'-6"
	22	ONE	35CB1	CRANE BEAM(S) (W24x55/C10x15.3) x	20'-6"
	23	4	36CS1	CRANE STOP(S) (W24x55 x 11 1/2") x	1'-0"
	24	16	36A1	CRANE BRACE(S) (L3x3x1/4") x	4'-11 1/4"
	25				
	26				
	27				



CAD FILE 3591-01BMC2	PLOTTING SCALE 1 = 1	SHEET NO. C2	JOB NO. 3591-01
DRAWN MLR	DATE 03/18/24	REVISION  05/01/24 - VR	
CHECKED VR	DATE 03/19/24	PHASE-1	

QTY. RECIEVED	ITEM	QTY.	MARK	DESCRIPTION Title Packing List	LENGTH
	1			HOT ROLL SHOP	
	2			FINISH: BLACK; SPECIAL PAINT BY OTHERS	
	3			(FLATE WHITE FSC #37875)	
	4				
	5	7	46B1	CABLE TRAY BEAM(S) (W10x22 x 3'-8 3/8") x	3'-9"
	6	3	47B1	CABLE TRAY BEAM(S) (W10x22 x 3'-8 3/8") x	3'-9"
	7	3	47B2	CABLE TRAY BEAM(S) (W10x22 x 3'-8 3/8") x	3'-9"
	8	2	48B1	CABLE TRAY BEAM(S) (W10x22 x 0'-8 3/8") x	0'-9"
	9	ONE	48B2	CABLE TRAY BEAM(S) (W10x22 x 0'-8 3/8") x	0'-9"
	10	ONE	49B1	CABLE TRAY BEAM(S) (W10x22 x 0'-5 1/2") x	0'-6 1/2"
	11	ONE	50B1	CABLE TRAY BEAM(S) (W10x22 x 3'-8 3/8") x	3'-9"
	12	2	51B1	CABLE TRAY BEAM(S) (W10x19) x	17'-11 1/2"
	13	ONE	51B2	CABLE TRAY BEAM(S) (W10x19) x	22'-5"
	14	2	51B3	CABLE TRAY BEAM(S) (W10x19) x	17'-11 1/2"
	15	6	52B1	CABLE TRAY BEAM(S) (W10x19) x	19'-11 1/2"
	16	ONE	53B1	CABLE TRAY BEAM(S) (W10x19 x 24'-1 7/8") x	24'-2 1/4"
	17	ONE	54B1	CABLE TRAY BEAM(S) (W10x19) x	19'-11 1/2"
	18	ONE	54B2	CABLE TRAY BEAM(S) (W10x19) x	19'-11 1/2"
	19	2	55B1	CABLE TRAY BEAM(S) (W10x19) x	13'-4 1/4"
	20	2	56B1	CABLE TRAY BEAM(S) (W10x19) x	22'-5"
	21	2	56B2	CABLE TRAY BEAM(S) (W10x19) x	18'-4 1/4"
	22	4	57B1	CABLE TRAY BEAM(S) (W10x19) x	21'-11 1/2"
	23				
	24	12	63C1	CABLE TRAY CHANNEL(S) (C10x15.3 x 2'-11") x	2'-11 3/4"
	25				
	26				
	27				



CAD FILE 3591-01BMC3	PLOTTING SCALE 1 = 1	SHEET NO. C3	JOB NO. 3591-01
DRAWN MLR	DATE 03/18/24	REVISION	
CHECKED VR	DATE 03/19/24	PHASE-1	


QTY. RECIEVED	ITEM	QTY.	MARK	DESCRIPTION Title Packing List	LENGTH
	1			HOT ROLL SHOP	
	2			FINISH: BLACK; SPECIAL PAINT BY OTHERS	
	3			(FLAT WHITE FSC #37875)	
	4				
	5	ONE	73SCI	SUPPORT COLUMN(S) (W8X18 x 7'-1 7/8") x	7'-2 7/8"
	6	2	74SCI	SUPPORT COLUMN(S) (W8X18 x 8'-9 7/8") x	8'-10 7/8"
	7	3	75SBI	SUPPORT BEAM(S) (W8X18) x	3'-1"
	8	6	76ANI	ANGLE(S) (L3x3x1/4) x	0'-6"
	9				
	10	ONE	44BK1	LADDER SUPPORT BRACKET(S) (W12X14 x 9 7/8") x	10 1/4"
	11	ONE	44BK2	LADDER SUPPORT BRACKET(S) (W12X14 x 1'-3 5/8") x	1'-4"
	12				
	13	ONE	45LBI	LADDER SUPPORT BEAM(S) (W8X18 x 18'-9 3/8") x	18'-9 3/4"
	14				
	15	2	K35R	LADDER GIRT CLIP(S) (43x3x3/16) x 1'-6 1/2"	1'-6 3/4"
	16	2	K35L	LADDER GIRT CLIP(S) (43x3x3/16) x 1'-6 1/2"	1'-6 3/4"
	17				
	18				
	19				
	20				
	21				
	22				
	23				
	24				
	25				
	26				
	27				



CAD FILE 3591-01BMC4	PLOTTING SCALE 1 = 1	SHEET NO. C4	JOB NO. 3591-01
DRAWN PSK	DATE 02/19/24	REVISION	
CHECKED BNB	DATE 02/19/24	PHASE-III	

QTY. RECIEVED	ITEM	QTY.	MARK	DESCRIPTION Title Packing List	LENGTH
	1			HOT ROLL SHOP	
	2			FINISH: BLACK; NO PAINT HOT DIP GALV. BY OTHERS	
	3				
	4	2	61BI	CABLE TRAY BEAM(S) (W10x22 x 5'-2 3/8") x	5'-3"
	5	2	62BI	CABLE TRAY BEAM(S) (W10x22 x 5'-2 3/8") x	5'-3"
	6	2	62B2	CABLE TRAY BEAM(S) (W10x22 x 5'-2 3/8") x	5'-3"
	7	2	98BI	CABLE TRAY BEAM(S) (W10x22 x 4'-5 3/8") x	4'-6"
	8	2	99BI	CABLE TRAY BEAM(S) (W10x22 x 4'-5 3/8") x	4'-6"
	9	3	99B2	CABLE TRAY BEAM(S) (W10x22 x 4'-5 3/8") x	4'-6"
	10	2	58BI	CABLE TRAY BEAM(S) (W10x19) x	17'-11 1/2"
	11	4	91BI	CABLE TRAY BEAM(S) (W10x19) x	22'-5"
	12	4	92BI	CABLE TRAY BEAM(S) (W10x19) x	19'-11 1/2"
	13	6	65BI	CABLE TRAY BEAM(S) (W10x19) x	18'-0 1/4"
	14	ONE	67BI	CABLE TRAY BEAM(S) (W10x22 x 5'-10 1/4") x	5'-10 7/8"
	15	7	94CI	CABLE TRAY CHANNEL(S) (C10x15.3 x 2'-11") x	2'-11 3/4"
	16	4	64CI	CABLE TRAY CHANNEL(S) (C10x15.3 x 3'-5") x	3'-5 3/4"
	17	2	68BI	CABLE TRAY BEAM(S) (W10x19) x	2'-2 7/8"
	18	4	96SBI	SUPPORT BEAM(S) (W8X18) x	3'-2"
	19	3	95SCI	SUPPORT COLUMN(S) (W8X18 x 7'-1 7/8") x	7'-2 7/8"
	20	ONE	95SC2	SUPPORT COLUMN(S) (W8X18 x 6'-2") x	6'-3"
	21				
	22	8	93ANI	ANGLE(S) (L3x3x1/4) x	0'-6"
	23				
	24	2	59BI	CABLE TRAY BEAM(S) (W10x19) x	21'-11 1/2"
	25	ONE	60AI	ANGLE(S) (L3x3x1/4) x	7'-11 3/4"
	26	ONE	60A2	ANGLE(S) (L3x3x1/4) x	7'-11 3/4"
	27				



CAD FILE 3591-01BMC5	PLOTTING SCALE 1 = 1	SHEET NO. C5	JOB NO. 3591-01
DRAWN MLR	DATE 03/8/24	REVISION  05/01/24 - VR	
CHECKED VR	DATE 03/19/24	PHASE-II	

QTY. RECIEVED	ITEM	QTY.	MARK	DESCRIPTION Title Packing List	LENGTH
	1			HOT ROLL SHOP	
	2			FINISH: RED OXIDE	
	3				
	4	ONE	21RBI	ROOF BEAM(S) (W8x18) X	18'-6"
	5	ONE	22RBI	ROOF BEAM(S) (W8x18) X	18'-6"
	6	ONE	23RBI	ROOF BEAM(S) (W8x18) X	22'-6"
	7	ONE	24RBI	ROOF BEAM(S) (W8x18) X	22'-6"
	8	ONE	25RBI	ROOF BEAM(S) (W8x18) X	20'-6"
	9	ONE	26RBI	ROOF BEAM(S) (W8x18) X	20'-6"
	10 	6	27RBI	ROOF SUPPORT BEAM(S) (W8x15 X 3'-7")	3'-4 3/4"
	11				
	12	ONE	69SBI	SUPPORT BEAM(S) (W8X18) x	22'-6 1/2"
	13	ONE	71SBI	SUPPORT BEAM(S) (W8X18) x	20'-6 1/2"
	14	ONE	72SBI	SUPPORT BEAM(S) (W8X18) x	18'-7 1/4"
	15	5	70BK1	SUPPORT BEAM(S) (W8X18 x 7 5/8") x	0'-8"
	16	ONE	70BK2	SUPPORT BEAM(S) (W8X18 x 1'-3 1/2") x	1'-3 7/8"
	17				
	18	2	80JI	JAMB(S) (C8x13.75 x 11'-7 3/4") x	12'-0"
	19	2	81HI	HEADER/SILL(S) (C8x13.75) x	2'-7"
	20	2	82JI	DOOR JAMB(S) (C8x11.5 x 23'-7 3/4") x	24'-0"
	21				
	22				
	23				
	24				
	25				
	26				
	27				



CAD FILE 3591-01BMC6	PLOTTING SCALE 1 = 1	SHEET NO. C6	JOB NO. 3591-01
DRAWN MLR	DATE 03/18/24	REVISION	
CHECKED VR	DATE 03/19/24	PHASE-III	

QTY. RECIEVED	ITEM	QTY.	MARK	DESCRIPTION Title Packing List	LENGTH
	1			HOT ROLL SHOP	
	2			FINISH: RED OXIDE	
	3				
	4			ROOF BEAM(S) (W) x	
	5			ROOF BEAM(S) (W) x	
	6				
	7			ROOF F.O. RAFTER(S) (W) x	
	8				
	9		K22A	GABLE GIRT CLIP(S) (8" Zee @ 1'-3") (4 3 x 3 x 1/4") x 1'-2"	1'-2 3/8"
	10		K22B	GABLE GIRT CLIP(S) (10" Zee @ 1'-3") (4 3 x 3 x 1/4") x 1'-1"	1'-1 3/8"
	11	8	K22C	GABLE GIRT CLIP(S) (A=10 1/2" B =1'-4") (4 3 x 3 x 1/4") x 1'-4"	1'-4 3/8"
	12				
	13				
	14				
	15				
	16 (+2)		K103	EAVE/JAMB CLIP(S) (43x3x3/16) x	0'-6"
	17		K113R	EAVE/JAMB CLIP(S) AT 10" JAMBS (43x3x3/16) x	0'-7"
	18 (+1)		K113L	EAVE/JAMB CLIP(S) AT 10" JAMBS (43x3x3/16) x	0'-7"
	19 (+1)		K112R	EAVE/JAMB CLIP(S) AT 12" JAMBS (43x3x3/16) x	0'-8"
	20 (+1)		K112L	EAVE/JAMB CLIP(S) AT 12" JAMBS (43x3x3/16) x	0'-8"
	21 (+1)				
	22 (+1)				
	23			ROOF LN. D LN. 5 LN. A LN. I PART	
	24 (+2)		K104	BASE CLIPS CLIP(S) (43x3x3/16) x	0'-6"
	25 (+2)		K105	HEADER/SILL CLIP(S) (43x3x3/16) x	0'-6"
	26 (+2)	54	K108	HEADER/SILL SLOTTED CLIP(S) (43x3x3/16) x	0'-6"
	27				



CAD FILE 3591-01BMC7	PLOTTING SCALE 1 = 1	SHEET NO. C7	JOB NO. 3591-01
DRAWN PSK	DATE 02/19/24	REVISION	
CHECKED BNB	DATE 02/19/24	PHASE-IV	

QTY. RECIEVED	ITEM	QTY.	MARK	DESCRIPTION	LENGTH
	1			HOT ROLL SHOP	
	2			FINISH: BLACK; SPECIAL PAINT BY OTHERS	
	3			SAFETY YELLOW	
	4	ONE	37LI	LADDER(S)	34'-5 5/16"
	5				
	6	ONE	38PTI	PLATFORM(S) (68x11.5) x	3'-0"
	7				
	8	ONE	39HRI	HANDRAIL(S)	4'-2 1/2"
	9	ONE	40HRI	HANDRAIL(S)	4'-2 1/2"
	10	ONE	41HRI	HANDRAIL(S)	4'-2 1/2"
	11				
	12				
	13	2	42AI	ANGLE(S)(43X3X3/8") x	2'-11 5/16"
	14				
	15	ONE	43LCI	LADDER CLIP(S)(45"x3"x1/4") x	1'-9 1/2"
	16				
	17				
	18				
	19				
	20				
	21				
	22				
	23				
	24				
	25				
	26				
	27				




CAD FILE 3591-01BMC8	PLOTTING SCALE 1 = 1	SHEET NO. C8	JOB NO. 3591-01
DRAWN PSK	DATE 02/14/24	REVISION	
CHECKED BNB	DATE 02/19/24	PHASE-V	

QTY. RECIEVED	ITEM	QTY.	MARK	DESCRIPTION Title Packing List	LENGTH
	1			HOT ROLL SHOP (ICE CANOPIES)	
	2			FINISH PAINT: Beige FSC #36415	
	3				
	4	4	88C1	ICE CANOPY(S) (PL 11GA x 75 1/2" x 3'-3 9/16 x	6'-0"
	5	ONE	89C1	ICE CANOPY(S) (2 - PL 11GA x 51 1/2" x 10'-0") x	19'-7 3/8"
	6				
	7	8	88SR1	3/4"Φ SUPPORT RODS (3/4"Φ ROD x 6'-9") x	5'-10"
	8	2	90SR1	3/4"Φ SUPPORT RODS (3/4"Φ ROD x 4'-6 1/4") x	3'-6 1/16"
	9	2	90SR2	3/4"Φ SUPPORT RODS (3/4"Φ ROD x 4'-8") x	3'-8 1/16"
	10	2	90SR3	3/4"Φ SUPPORT RODS (3/4"Φ ROD x 4'-10 7/8") x	3'-10 7/8"
	11				
	12	14	IVS-1	CANOPY-ROD CLIP(S) (45 x 3 x 1/4 x 0'-3") x	(2 PER CANOPY) 0'-3"
	13	28	IVS-8	CANOPY CLIP(S) (1 1/4"x 3" x 1'-3") (FOR 8" JAMBS)	STD. PARTS BY IVS (4 PER CANOPY) 1'-3"
	14		IVS-10	CANOPY CLIP(S) (1 1/4"x 3" x 1'-4") (FOR 10" JAMBS)	(4 PER CANOPY) 1'-4"
	15		IVS-12	CANOPY CLIP(S) (1 1/4"x 3" x 1'-5") (FOR 12" JAMBS)	(4 PER CANOPY) 1'-5"
	16				
	17				
	18				
	19				
	20				
	21				
	22			PIPE SPACERS (3/4"Φ STD. PIPE)	
	23				
	24	ONE		ICE CANOPY PEAK SIGN (ONE PER BUILDING ONLY)	
	25				
	26				
	27				



CAD FILE 3591-01BMC9	PLOTTING SCALE 1" = 1'-0"	SHEET NO. C9	JOB NO. 3591-01
DRAWN PSK	DATE 02/19/24	REVISION	
CHECKED BNB	DATE 02/19/24	PHASE-1	

STRUCTURAL		FINISH: BLACK; SPECIAL PAINT BY OTHERS (FLAT WHITE FSC #37875)				
QTY. RECIEVED	ITEM	QTY.	MARK	DESCRIPTION		LENGTH
	1	6	FB-1	FLANGE BRACES (4 2 x 2 x 1/8") x		3'-4 3/4"
	2	10	FB-2	FLANGE BRACES (4 2 x 2 x 1/8") x		3'-11 3/4"
	3	10	FB-3	FLANGE BRACES (4 2 x 2 x 1/8") x		3'-10 3/8"
	4	10	FB-4	FLANGE BRACES (4 2 x 2 x 1/8") x		3'-7 5/8"
	5	40	FB-5	FLANGE BRACES (4 2 x 2 x 1/8") x		3'-7 1/2"
	6	16	FB-6	FLANGE BRACES (4 2 x 2 x 1/8") x		2'-5 3/4"

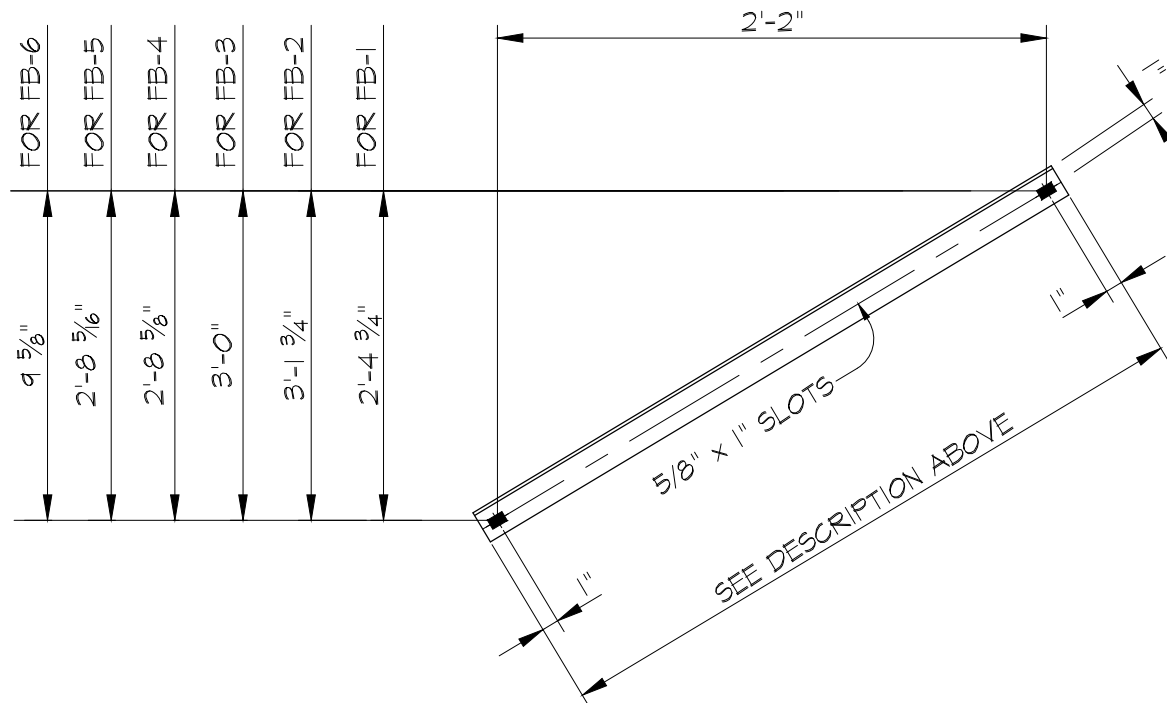



CAD FILE 3591-01BMC10	PLOTTING SCALE 1" = 1"	SHEET NO. C10	JOB NO. 3591-01
DRAWN PSK	DATE 02/19/24	REVISION	
CHECKED BNB	DATE 02/19/24	PHASE-1	

QTY. RECIEVED	ITEM	QTY.	MARK	DESCRIPTION	LENGTH
	1			HOT ROLL SHOP (BRACE RODS)	
	2			FINISH: BLACK; SPECIAL PAINT BY OTHERS (FLAT WHITE FSC #37875)	
	3	2	RB-1	1/2"Φ ROD(S) (BAY =18'-6 1/2") X (SLOT =15'-1 5/16") + 8"	24'-7 1/4"
	4	2	RB-2	1/2"Φ ROD(S) (BAY =18'-6 1/2") X (SLOT =8'-2 13/16") + 8"	20'-11 1/2"
	5	2	RB-3	1/2"Φ ROD(S) (BAY =20'-6 1/2") X (SLOT =15'-1 5/16") + 8"	26'-2"
	6				
	7	2	RB-5	5/8"Φ ROD(S) (BAY =18'-6 1/2") X (SLOT =18'-4 1/8") + 8"	26'-9"
	8	2	RB-6	5/8"Φ ROD(S) (BAY =18'-6 1/2") X (SLOT =25'-2 3/4") + 8"	31'-11 3/4"
	9	2	RB-7	5/8"Φ ROD(S) (BAY =20'-6 1/2") X (SLOT =18'-4 1/8") + 8"	28'-2 1/2"
	10				
	11		RB	3/4"Φ ROD(S) (BAY =) X (SLOT =) + 8"	
	12		RB	3/4"Φ ROD(S)	
	13		RB	3/4"Φ ROD(S)	
	14				
	15		RB	1"Φ ROD(S) (BAY =) X (SLOT =) + 10"	
	16		RB	1"Φ ROD(S)	
	17		RB	1"Φ ROD(S)	





CAD FILE 3591-01BMC11	PLOTTING SCALE 1" = 1"	SHEET NO. C11	JOB NO. 3591-01
DRAWN PSK	DATE 02/19/24	REVISION	
CHECKED BNB	DATE 02/19/24	PHASE-I	

QTY. RECIEVED	ITEM	QTY.	MARK	DESCRIPTION	LENGTH
	1			HOT ROLL SHOP (BRACE RODS)	
	2			FINISH: BLACK; SPECIAL PAINT BY OTHERS (FLAT WHITE FSC #37875)	
	3	2	RB-4	1/2"Φ ROD(S) (BAY = 20'-6 1/2") X (SLOT = 8'-2 13/16") + 8"	22'-9 3/4"
	4		RB	1/2"Φ ROD(S) (BAY =) X (SLOT =) + 8"	
	5		RB	1/2"Φ ROD(S) (BAY =) X (SLOT =) + 8"	
	6				
	7	2	RB-8	5/8"Φ ROD(S) (BAY = 20'-6 1/2") X (SLOT = 25'-2 3/4") + 8"	33'-2 1/2"
	8		RB	5/8"Φ ROD(S) (BAY =) X (SLOT =) + 8"	
	9		RB	5/8"Φ ROD(S) (BAY =) X (SLOT =) + 8"	
	10				
	11	4	RB-9	3/4"Φ ROD(S) (BAY = 18'-6 1/2") X (SLOT = 9'-6 7/16") + 8"	21'-6 1/4"
	12	4	RB-10	3/4"Φ ROD(S) (BAY = 20'-6 1/2") X (SLOT = 9'-6 7/16") + 8"	23'-3 3/4"
	13		RB	3/4"Φ ROD(S)	
	14				
	15		RB	1"Φ ROD(S) (BAY =) X (SLOT =) + 10"	
	16		RB	1"Φ ROD(S)	
	17		RB	1"Φ ROD(S)	






CAD FILE 3591-01BMDI	PLOTTING SCALE 1 = 1	SHEET NO. DI	JOB NO. 3591-01
DRAWN PSK	DATE 02/19/24	REVISION	
CHECKED BNB	DATE 02/19/24	PHASE-II	

QTY. RECIEVED	ITEM	QTY.	MARK	DESCRIPTION Title Packing List	LENGTH
	1			FABRICATED COLD FORM SHOP	
	2			FINISH: RED OXIDE	
	3				
	4	6	77JI	DOOR JAMB(S) (8C2½ x 14GA x 11'-7 3/4") x	12'-0"
	5	2	78JI	DOOR JAMB(S) (8C2½ x 14GA x 7'-3 3/8") x	7'-3 5/8"
	6				
	7	3	79HI	DOOR HEADER(S) (8C2½ x 14GA) x	3'-4"
	8	ONE	83HI	DOOR HEADER(S) (8C3½ x 14GA) x	18'-0"
	9	ONE	84HI	DOOR HEADER(S) (8C3½ x 14GA) x	18'-0"
	10				
	11	3	85SI	DOOR SILL(S) (8C3½ x 14GA) x	2'-7"
	12				
	13	2	86RO	ROOF HEADER(S) (8C3½ x 12GA x 3'-4 1/2") x	3'-10 1/16"
	14	2	87RO	ROOF HEADER(S) (8C3½ x 12GA x 3'-4 1/2") x	3'-10 1/16"
	15				
	16				
	17				
	18				
	19				
	20				
	21				
	22				
	23				
	24				
	25				
	26				
	27				



CAD FILE 3591-01BME1	PLOTTING SCALE 3/4" = 1'	SHEET NO. E1	JOB NO. 3591-01
DRAWN PSK	DATE 02/19/24	REVISION	
CHECKED BNB	DATE 02/19/24	PHASE-II	

COLD FORM		FINISH: RED OXIDE					8ES x 12GA					
QTY. RECIEVED	ITEM	QTY.	MARK	F	F1	F2	F3	W	W1	W2	W3	LENGTH
	1	ONE	ESLF-1	1'-2 3/4"	1'-6 3/4"			6'-9 3/4"				19'-11"
	2	2	ESLF-2									22'-6"
	3	2	ESLF-3									20'-6"
	4	ONE	ESLF-4	20'-4 1/4"	20'-8 1/4"			15'-1 1/4"				21'-11"
	5	ONE	ESLF-5	18'-4 1/4"	18'-8 1/4"			13'-1 1/4"				19'-11"
	6	ONE	ESLF-6	1'-2 3/4"	1'-6 3/4"			6'-9 3/4"				21'-11"
	7											
	8											
	9											
	10											

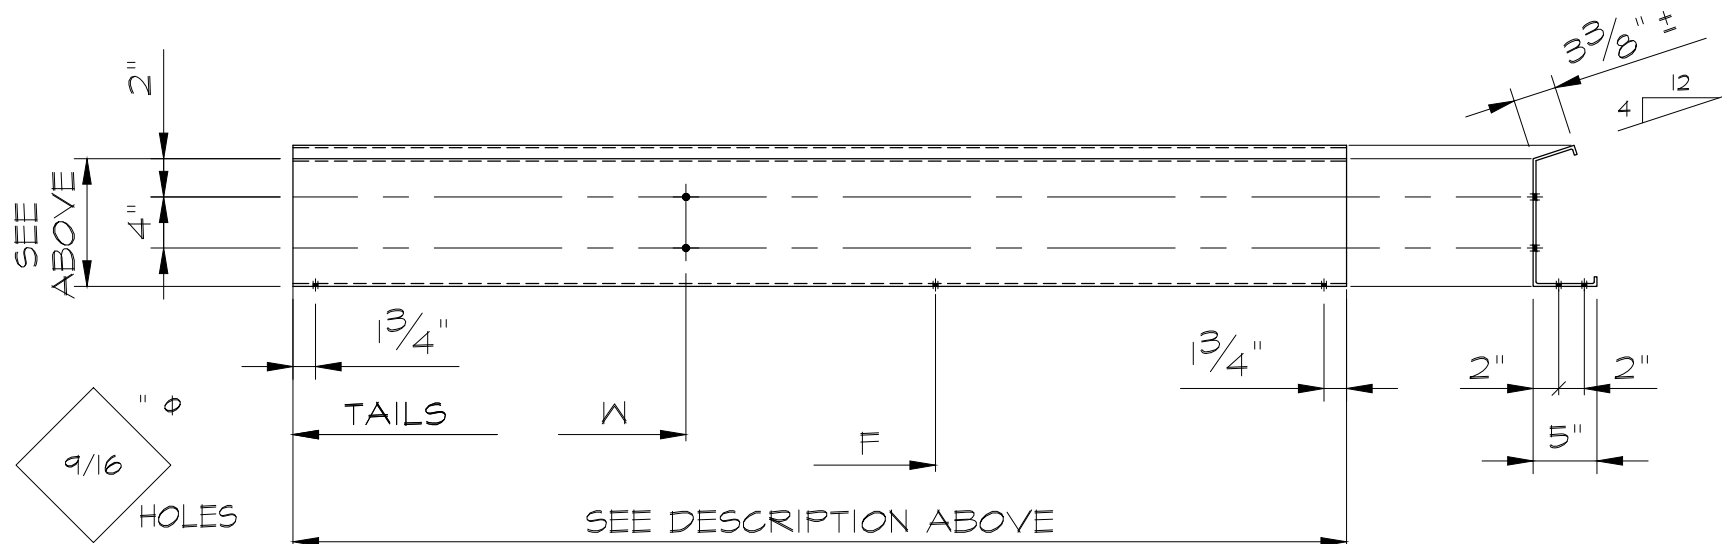



CAD FILE 3591-01BME2	PLOTTING SCALE 1 = 1	SHEET NO. E2	JOB NO. 3591-01
DRAWN MLR	DATE 03/18/24	REVISION	
CHECKED VR	DATE 03/19/24	PHASE-II	


QTY. RECIEVED	ITEM	QTY.	MARK	DESCRIPTION Title Packing List		LENGTH
	1			ROLLED COLD FORM SHOP		
	2			FINISH: RED-OXIDE		
	3					
	4	ONE	PM1	CAP CHANNEL	±8" <div>8 1/8"</div> 5 13/16"	6'-0"
	5			21 15/16" GIRTH GA= 14		
	6					
	7					
	8	ONE	PM3	CAP CHANNEL	±4" <div>8 1/8"</div> 3 13/16"	3'-4"
	9			15 15/16" GIRTH GA= 14		
	10					
	11					
	12					
	13					
	14					
	15					
	16					
	17					
	18					
	19					
	20					
	21					
	22					
	23					
	24					
	25					
	26					
	27					



CAD FILE 3591-01BME3	PLOTTING SCALE 3/4" = 1'	SHEET NO. E3	JOB NO. 3591-01
DRAWN MLR	DATE 03/18/24	REVISION	
CHECKED VR	DATE 03/19/24	PHASE-III	

COLD FORM		FINISH: RED OXIDE						8Z3½ x12GA				
QTY. RECIEVED	ITEM	QTY.	MARK	W	W1	W2	W3	W4	W5	W6	W7	LENGTH
	1	9	ZGU-30	1'-2 ¾"	1'-6 ¾"	3'-8 ¾"	6'-9 ¾"					23'-1"
	2	9	ZUG-31	18'-3 ¼"	21'-4 ¼"	23'-6 ¼"	23'-10 ¼"					25'-1"
	3	9	ZUG-32	16'-3 ¼"	19'-4 ¼"	21'-6 ¼"	21'-10 ¼"					23'-1"
	4	9	ZGU-33	1'-2 ¾"	1'-6 ¾"	3'-8 ¾"	6'-9 ¾"					25'-1"
	5	2	ZGG-34	1'-2 ¾"	1'-6 ¾"	9'-4 7/8"	9'-8 7/8"					10'-11 5/8"
	6	2	ZGU-35									8'-1 1/8"
	7	2	ZUG-36									8'-1 1/8"
	8	2	ZGG-37	1'-2 ¾"	1'-6 ¾"	11'-4 7/8"	11'-8 7/8"					12'-11 5/8"
	9	ONE	ZSX-38	3'-6 ¼"	4'-5 ¾"	5'-10 ¼"	8'-5 ¾"	12'-5 ¾"	16'-6 ½"	18'-2 ½"		22'-7 ¼"
	10 (+1)	2	ZXX-39	0'-6 ¾"	5'-1 3/8"	8'-0 3/8"	10'-11 3/8"	14'-16 3/8"	18'-1 3/8"	22'-7 ¼"		21'-7 ¼"

Part No. ZGG-1		
LEADING PUNCH TAILING PUNCH		
PUNCH CODE	TOTAL LAP	MINIMUM LENGTH
ZGG-		0'-5 ½"
ZSS-	7 ½"	5'-5 ½"
ZLL-	2'-5 ½"	7'-3 ½"
ZXX-	4'-11 ½"	9'-9 ½"
ZUU-	6'-3 ½"	12'-5 ½"

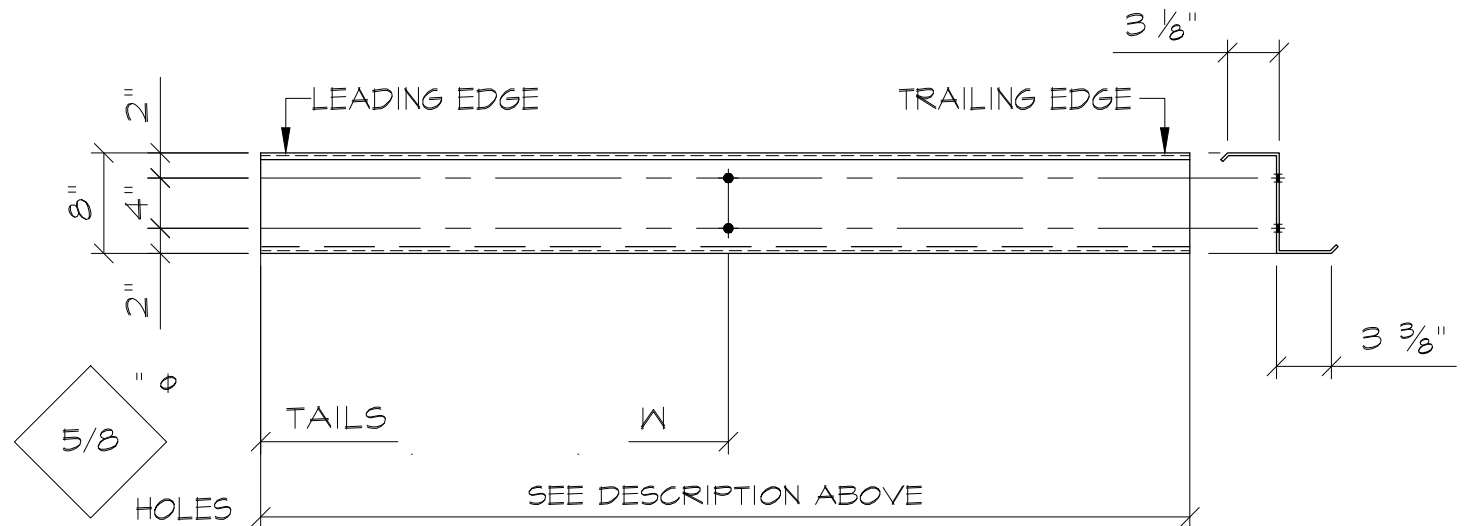




CAD FILE 3591-01BME4	PLOTTING SCALE 3/4" = 1'	SHEET NO. E4	JOB NO. 3591-01
DRAWN MLR	DATE 03/18/24	REVISION	
CHECKED VR	DATE 03/19/24	PHASE-II	

COLD FORM		FINISH: RED OXIDE					8Z3½ x12GA					
QTY. RECIEVED	ITEM	QTY.	MARK	W	W1	W2	W3	W4	W5	W6	W7	LENGTH
	1	ONE	ZGS-40	1'-9 ½"	2'-3 ¾"	5'-3 ¾"	8'-9 ¾"	13'-1 ¾"	16'-7 ¾"	20'-2"		25'-1 ¼"
	2	ONE	ZGG-41	5 ¾"	3'-6 ¼"	5'-10 ¼"	8'-5 ¾"	12'-5 ¾"				16'-8 ¼"
	3	ONE	ZGG-42	3'-0 ¾"	5'-11 ¾"	9'-6 ¾"	13'-1 ¾"					16'-7 ⅝"
	4	ONE	ZGG-43	3'-1 ¾"	6'-7 ¾"	10'-11 ¾"	14'-5 ¾"	18'-0"	22'-5 ½"			22'-11 ¼"
	5											
	6											
	7											
	8											
	9											
	10											

Part No. ZGG-1		
LEADING PUNCH TAILING PUNCH		
PUNCH CODE	TOTAL LAP	MINIMUM LENGTH
ZGG-		0'-5 ½"
ZSS-	7 ½"	5'-5 ½"
ZLL-	2'-5 ½"	7'-3 ½"
ZXX-	4'-11 ½"	9'-9 ½"
ZUU-	6'-3 ½"	12'-5 ½"

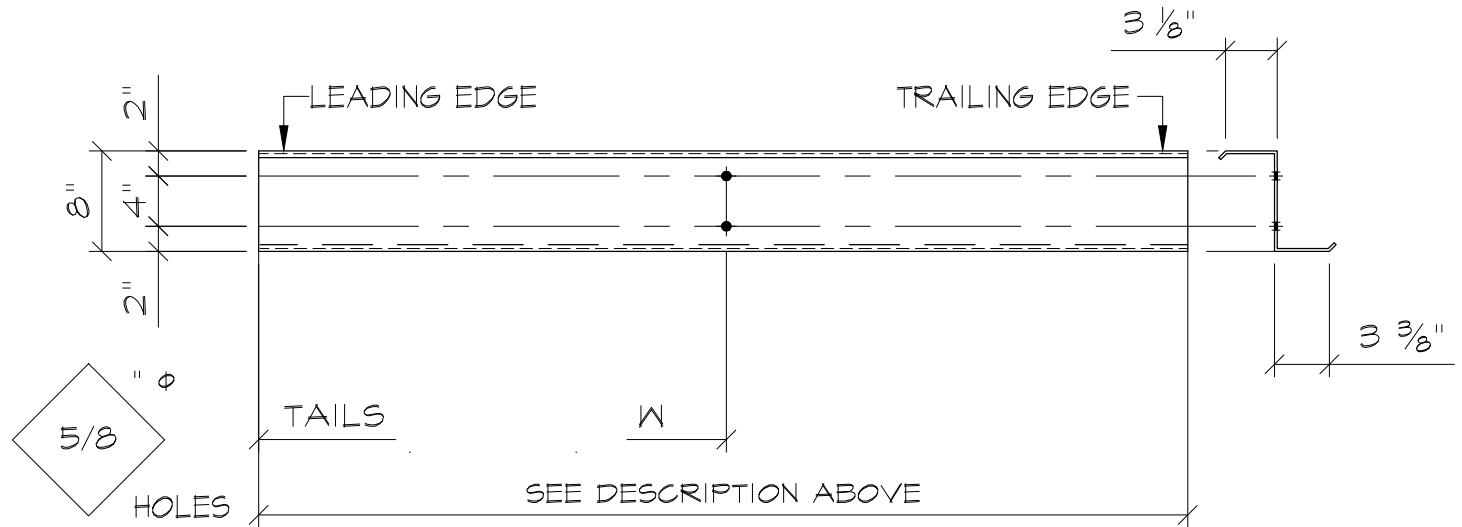




CAD FILE 3591-01BME5	PLOTTING SCALE 3/4" = 1'	SHEET NO. E5	JOB NO. 3591-01
DRAWN MLR	DATE 03/18/24	REVISION	
CHECKED VR	DATE 03/19/24	PHASE-II	

COLD FORM		FINISH: RED OXIDE					8Z3½ x14GA					
QTY. RECIEVED	ITEM	QTY.	MARK	W	W1	W2	W3	W4	W5	W6	W7	LENGTH
	1	9	ZUX-50									28'-2"
	2	9	ZXU-51									28'-2"
	3	ONE	ZUG-52									17'-8 ⅛"
	4	ONE	ZGX-53									6'-5 ⅝"
	5	ONE	ZXG-54									6'-5 ⅝"
	6	10	ZXU-55									26'-2"
	7	10	ZUX-56									26'-2"
	8	ONE	ZGU-57									17'-8 ⅛"
	9	ONE	ZSG-58	1'-2 ¾"	1'-6 ¾"	9'-3 ¾"	12'-1 ¾"	21'-9 ¼"	22'-1 ¼"			23'-0 ½"
	10											

Part No. ZGG-1		
LEADING PUNCH TAILING PUNCH		
PUNCH CODE	TOTAL LAP	MINIMUM LENGTH
ZGG-		0'-5 ½"
ZSS-	7 ½"	5'-5 ½"
ZLL-	2'-5 ½"	7'-3 ½"
ZXX-	4'-11 ½"	9'-9 ½"
ZUU-	6'-3 ½"	12'-5 ½"

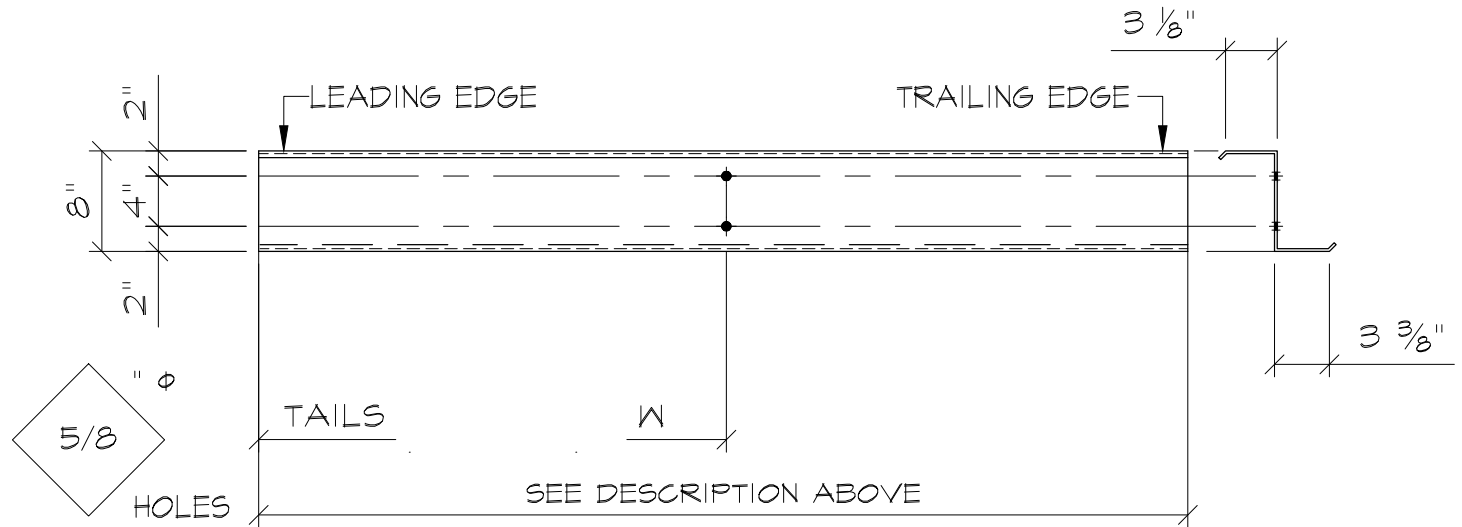



CAD FILE
3591-01BME7

PLOTTING SCALE
3/4" = 1'

SHEET NO.
E7

JOB NO.
3591-01

DRAWN
PSK

DATE
02/19/24

REVISION


CHECKED
BNB

DATE
02/19/24

PHASE-II

COLD FORM		FINISH: RED OXIDE					8Z2½ x12GA					
QTY. RECIEVED	ITEM	QTY.	MARK	W	W1	W2	W3	W4	W5	W6	W7	LENGTH
	1	2	ZXS-70									27'-7 ¼"
	2											
	3											
	4											
	5											
	6											
	7											
	8											
	9											
	10											

Part No. ZGG-1		
LEADING PUNCH TAILING PUNCH		
PUNCH CODE	TOTAL LAP	MINIMUM LENGTH
ZGG-		0'-5 ½"
ZSS-	7 ½"	5'-5 ½"
ZLL-	2'-5 ½"	7'-3 ½"
ZXX-	4'-11 ½"	9'-9 ½"
ZUU-	6'-3 ½"	12'-5 ½"

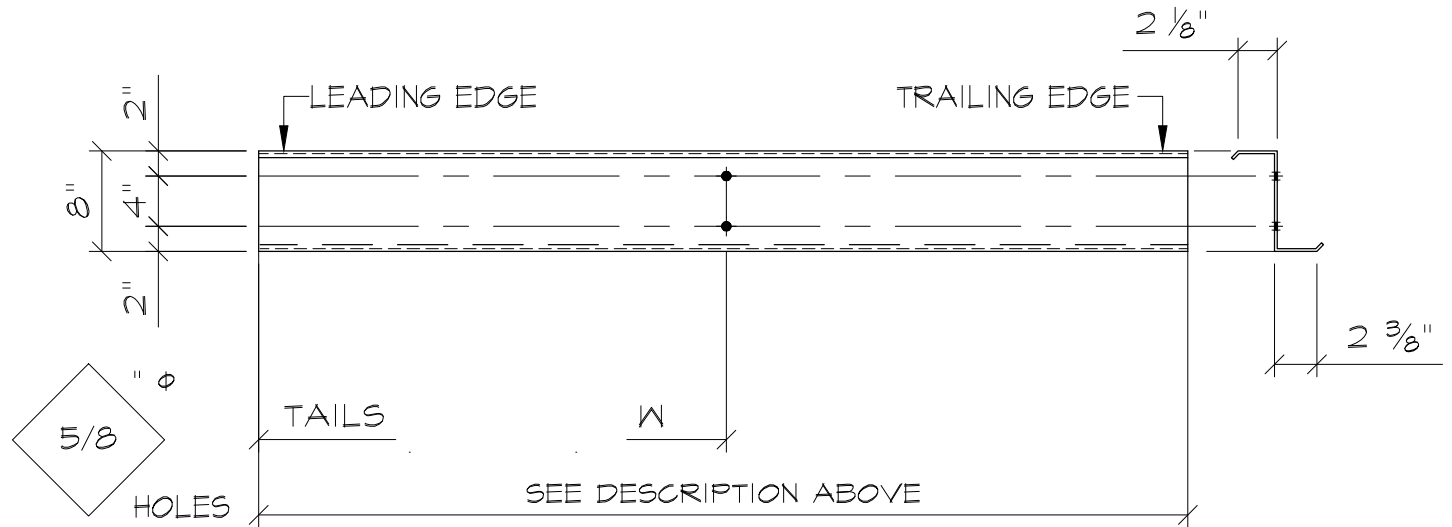




CAD FILE 3591-01BME8	PLOTTING SCALE 3/4" = 1'	SHEET NO. E8	JOB NO. 3591-01
DRAWN MLR	DATE 03/18/24	REVISION	
CHECKED VR	DATE 03/19/24	PHASE-II	

COLD FORM		FINISH: RED OXIDE					8Z2½ x14GA					
QTY. RECIEVED	ITEM	QTY.	MARK	W	W1	W2	W3	W4	W5	W6	W7	LENGTH
	1	ONE	ZXX-80									27'-11 ½"
	2	5	ZXS-81									22'-7 ¼"
	3	ONE	ZSX-82									22'-7 ¼"
	4	ONE	ZXX-83									27'-11 ½"
	5	ONE	ZSX-84	1'-2 ¾"	1'-6 ¾"	9'-3 ¾"	12'-1 ¾"	23'-2 ½"				24'-5"
	6	ONE	ZXX-85	3'-9"	6'-8 ½"	8'-5 ¼"	12'-1 ¼"	14'-7 ¼"	18'-3 ¼"			25'-6"
	7	ONE	ZGX-86			11'-0 ¾"	11'-4 ¾"					13'-6 ⅞"
	8	ONE	ZXX-87	6'-11 ⅞"	9'-9 ⅞"	10'-11 ⅞"	13'-9 ⅞"					27'-6"
	9	ONE	ZXS-88	10'-8 ¾"	16'-1 ¾"	20'-10 ¼"	21'-2 ¼"					22'-5"
	10	ONE	ZXX-89	6'-11 ⅞"	9'-9 ⅞"	10'-11 ⅞"	13'-9 ⅞"	15'-7 ¾"	21'-11 ¾"			27'-6"

Part No. ZGG-1		
LEADING PUNCH TAILING PUNCH		
PUNCH CODE	TOTAL LAP	MINIMUM LENGTH
ZGG-		0'-5 ½"
ZSS-	7 ½"	5'-5 ½"
ZLL-	2'-5 ½"	7'-3 ½"
ZXX-	4'-11 ½"	9'-9 ½"
ZUU-	6'-3 ½"	12'-5 ½"

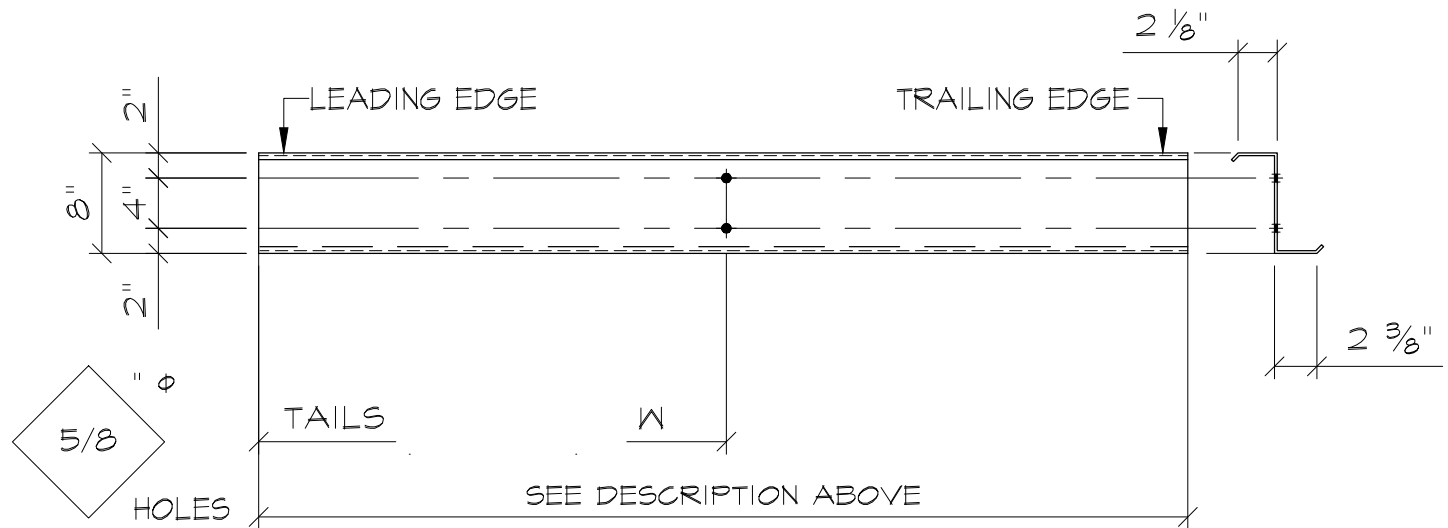




CAD FILE 3591-01BME9	PLOTTING SCALE 3/4" = 1'	SHEET NO. E9	JOB NO. 3591-01
DRAWN MLR	DATE 03/18/24	REVISION	
CHECKED VR	DATE 03/19/24	PHASE-II	

COLD FORM		FINISH: RED OXIDE						8Z2½ x14GA				
QTY. RECIEVED	ITEM	QTY.	MARK	W	W1	W2	W3	W4	W5	W6	W7	LENGTH
	1	ONE	ZGS-90	2'-8 ½"	3'-0 ½"	21'-3"	21'-7"					22'-9 ¾"
	2											
	3											
	4											
	5											
	6											
	7											
	8											
	9											
	10											

Part No. ZGG-1		
LEADING PUNCH TAILING PUNCH		
PUNCH CODE	TOTAL LAP	MINIMUM LENGTH
ZGG-		0'-5 ½"
ZSS-	7 ½"	5'-5 ½"
ZLL-	2'-5 ½"	7'-3 ½"
ZXX-	4'-11 ½"	9'-9 ½"
ZUU-	6'-3 ½"	12'-5 ½"

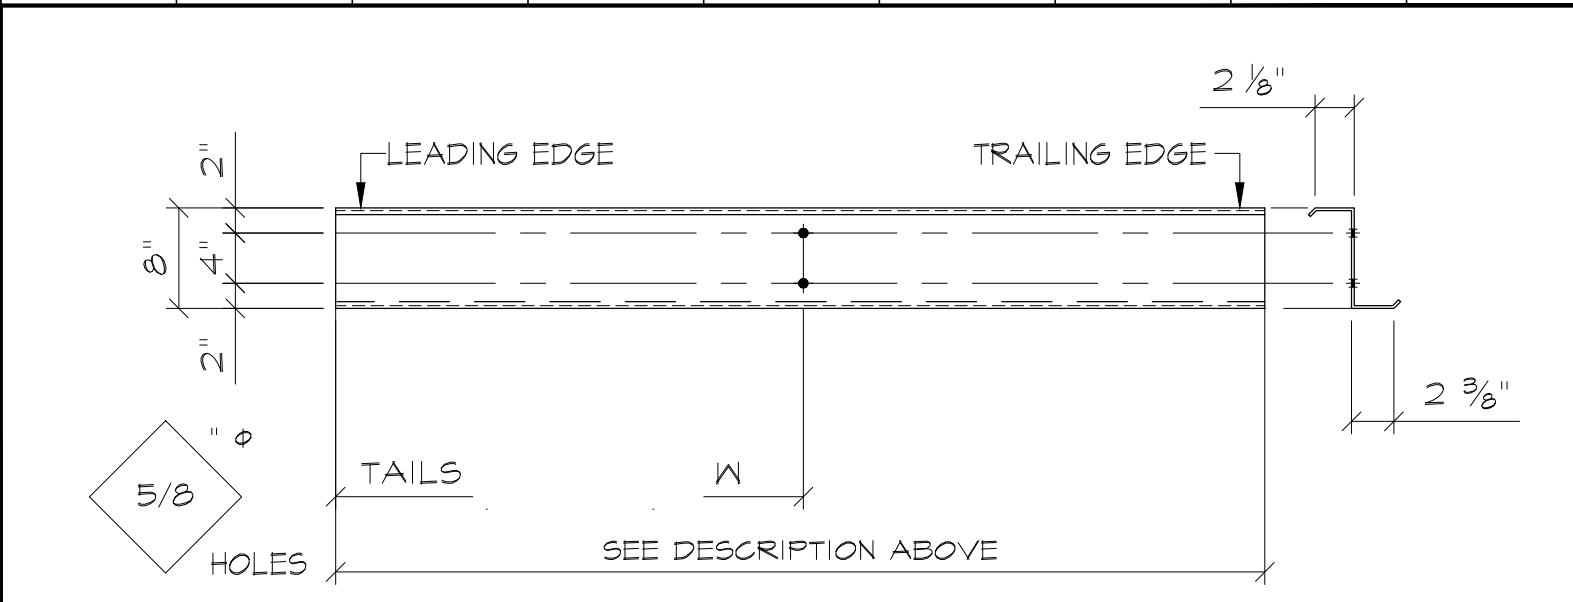




CAD FILE 3591-01BME10	PLOTTING SCALE 3/4" = 1'	SHEET NO. E10	JOB NO. 3591-01
DRAWN MLR	DATE 03/18/24	REVISION	
CHECKED VR	DATE 03/19/24	PHASE-II	

COLD FORM		FINISH: RED OXIDE					8Z2½ x16GA					
QTY. RECIEVED	ITEM	QTY.	MARK	W	W1	W2	W3	W4	W5	W6	W7	LENGTH
	1	20	ZGG-100	1'-2 ¾"	1'-6 ¾"							6'-7 ¾"
	2	20	ZGG-101	5'-1"	5'-5"							6'-7 ¾"
	3	2	ZGG-102									21'-10 ¾"
	4	4	ZSX-103	1'-2 ¾"	1'-6 ¾"							24'-5"
	5	4	ZXX-104									25'-6"
	6	ONE	ZGG-105									1'-6"
	7	ONE	ZGG-106									2'-6 ½"
	8	ONE	ZGX-107	2'-5 ¼"	6'-1 ¼"							13'-4"
	9	ONE	ZXG-108									6'-9 ⅛"
	10	ONE	ZGG-109									0'-10"

Part No. ZGG-1		
LEADING PUNCH TAILING PUNCH		
PUNCH CODE	TOTAL LAP	MINIMUM LENGTH
ZGG-		0'-5 ½"
ZSS-	7 ½"	5'-5 ½"
ZLL-	2'-5 ½"	7'-3 ½"
ZXX-	4'-11 ½"	9'-9 ½"
ZUU-	6'-3 ½"	12'-5 ½"

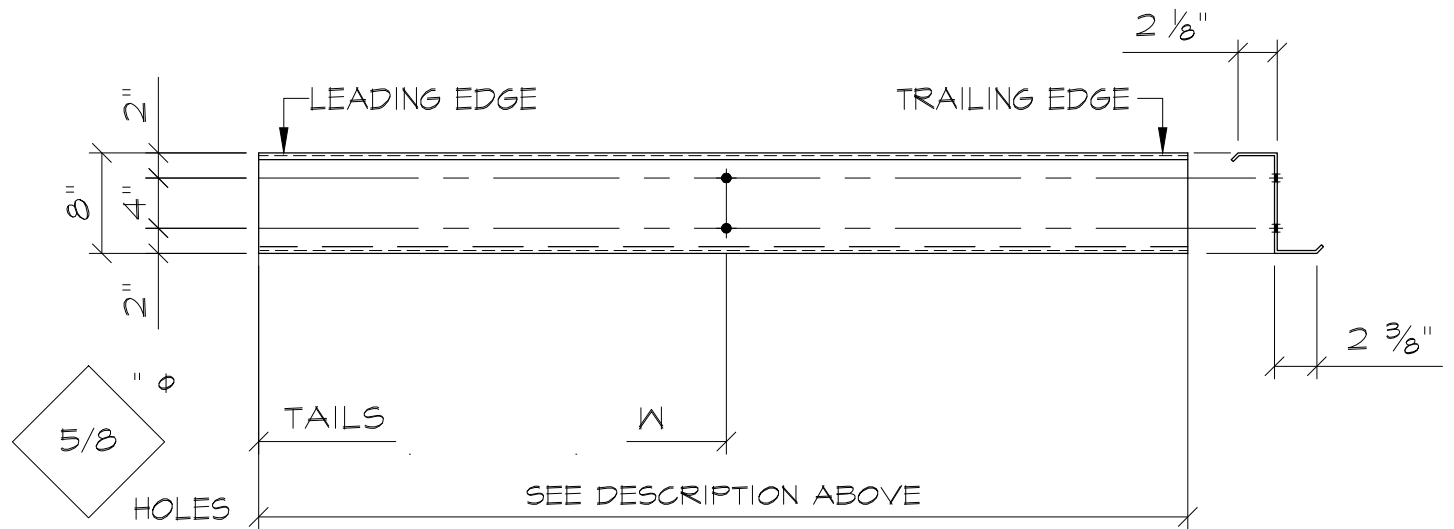




CAD FILE 3591-01BME11	PLOTTING SCALE 3/4" = 1'	SHEET NO. E11	JOB NO. 3591-01
DRAWN PSK	DATE 02/19/24	REVISION	
CHECKED BNB	DATE 02/19/24	PHASE-II	

COLD FORM		FINISH: RED OXIDE					8Z2½ x16GA					
QTY. RECIEVED	ITEM	QTY.	MARK	W	W1	W2	W3	W4	W5	W6	W7	LENGTH
	1	2	ZSX-110									22'-7 ¼"
	2	ONE	ZGX-111									14'-5 ⅝"
	3	ONE	ZXX-112									27'-11 ½"
	4	ONE	ZXG-113									19'-5 ⅝"
	5	ONE	ZGG-114	11'-9 ⅜"	13'-11 ⅜"	14'-3 ⅜"						15'-6 ⅞"
	6	ONE	ZXG-115									17'-10"
	7	ONE	ZGG-116	3'-8 ¼"	4'-0 ¼"							5'-3 ¾"
	8	3	ZGS-117									4'-7"
	9	4	ZXX-118									25'-6"
	10	ONE	ZXX-119	4 ¾"								25'-6"

Part No. ZGG-1		
LEADING PUNCH TAILING PUNCH		
PUNCH CODE	TOTAL LAP	MINIMUM LENGTH
ZGG-		0'-5 ½"
ZSS-	7 ½"	5'-5 ½"
ZLL-	2'-5 ½"	7'-3 ½"
ZXX-	4'-11 ½"	9'-9 ½"
ZUU-	6'-3 ½"	12'-5 ½"

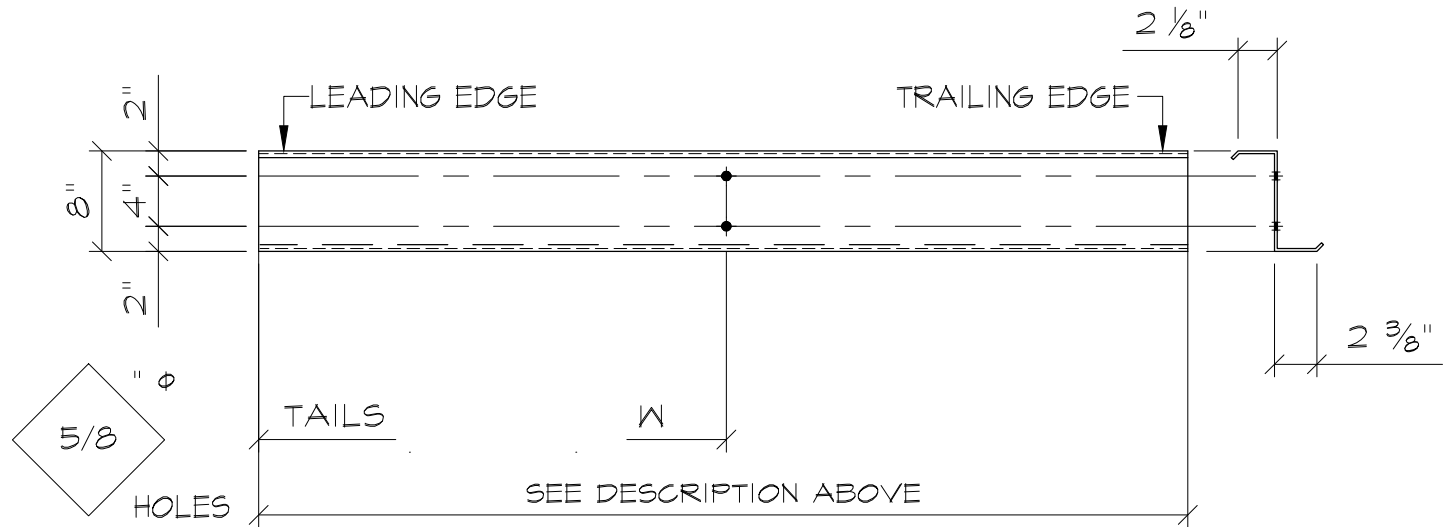





CAD FILE 3591-01BME12	PLOTTING SCALE 3/4" = 1'	SHEET NO. E12	JOB NO. 3591-01
DRAWN MLE	DATE 03/18/24	REVISION	
CHECKED VR	DATE 03/19/24	PHASE-II	

COLD FORM	FINISH: RED OXIDE	8Z2½ x16GA
-----------	-------------------	------------

QTY. RECIEVED	ITEM	QTY.	MARK	W	W1	W2	W3	W4	W5	W6	W7	LENGTH
	1	ONE	ZGX-120	1'-10 ¼"	2'-2 ¼"							25'-0 ½"
	2	5	ZXS-121	22'-10 ¼"	23'-2 ¼"							24'-5"
	3	ONE	ZXS-122	7'-3 ¼"	10'-2 ¼"	22'-10 ¼"	23'-2 ¼"					24'-5"
	4	ONE	ZXG-123									19'-2 ½"
	5	ONE	ZGX-124									10'-10"
	6	ONE	ZXG-125									15'-5 ¾"
	7	ONE	ZGS-126	4'-6 ½"	4'-10 ½"							6'-1 ¼"
	8	6	ZSX-127	1'-2 ¾"	1'-6 ¾"							22'-5"
	9											
	10	5	ZXX-129									27'-6"

Part No. ZGG-1		
LEADING PUNCH TAILING PUNCH		
PUNCH CODE	TOTAL LAP	MINIMUM LENGTH
ZGG-		0'-5 ½"
ZSS-	7 ½"	5'-5 ½"
ZLL-	2'-5 ½"	7'-3 ½"
ZXX-	4'-11 ½"	9'-9 ½"
ZUU-	6'-3 ½"	12'-5 ½"

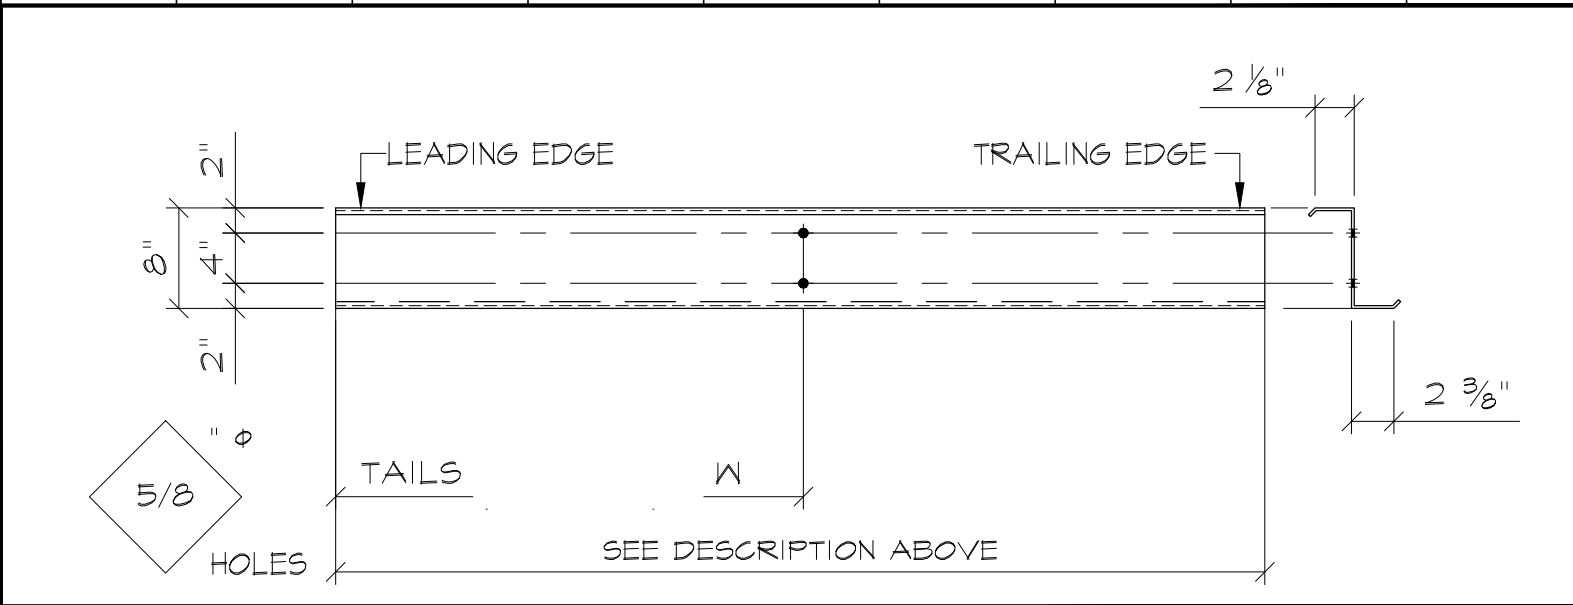


 

REVISION

PHASE-II

8C3½ x 12GA

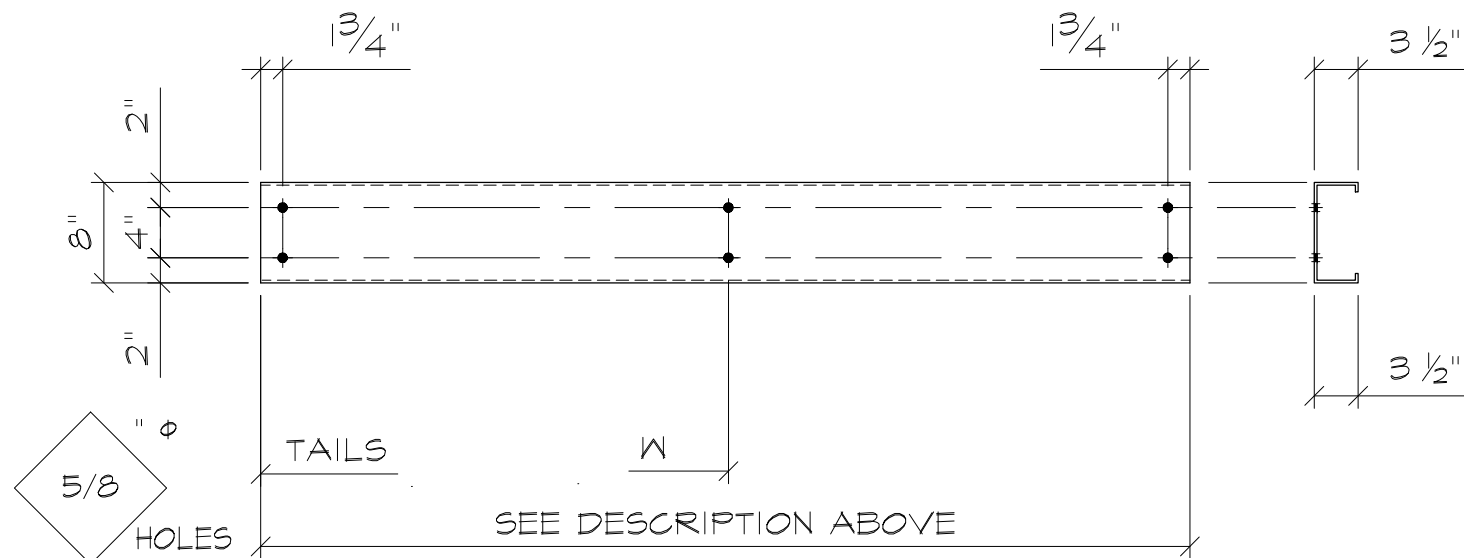


PUNCH CODE	MINIMUM LENGTH
CGG-	0'-5 1/2"



CAD FILE 3591-01BME14	PLOTTING SCALE 3/4" = 1'	SHEET NO. E14	JOB NO. 3591-01
DRAWN PSK	DATE 02/19/24	REVISION	
CHECKED BNB	DATE 02/19/24	PHASE-II	


COLD FORM		FINISH: RED OXIDE					8C3½ x14GA					
QTY. RECIEVED	ITEM	QTY.	MARK	W	W1	W2	W3	W4	W5	W6	W7	LENGTH
	1	2	CGG-140	9"	4'-5"							5'-8"
	2	2	CGG-141									3'-4"
	3	2	CGG-142	1'-5"	3'-9"							5'-8"
	4	2	CGG-143									2'-0"
	5	2	CGG-144	1'-6"	4'-4"							5'-4"
	6	6	CGG-145									2'-6"
	7	2	CGG-146	6 ⅛"	4'-2 ⅛"							5'-4"
	8	4	CGG-147	3'-2"	5'-6"	6'-0"						11'-4"
	9	2	CGG-148	5'-7"	6'-5 ¼"							11'-5"
	10	3	CGG-149									6'-0"

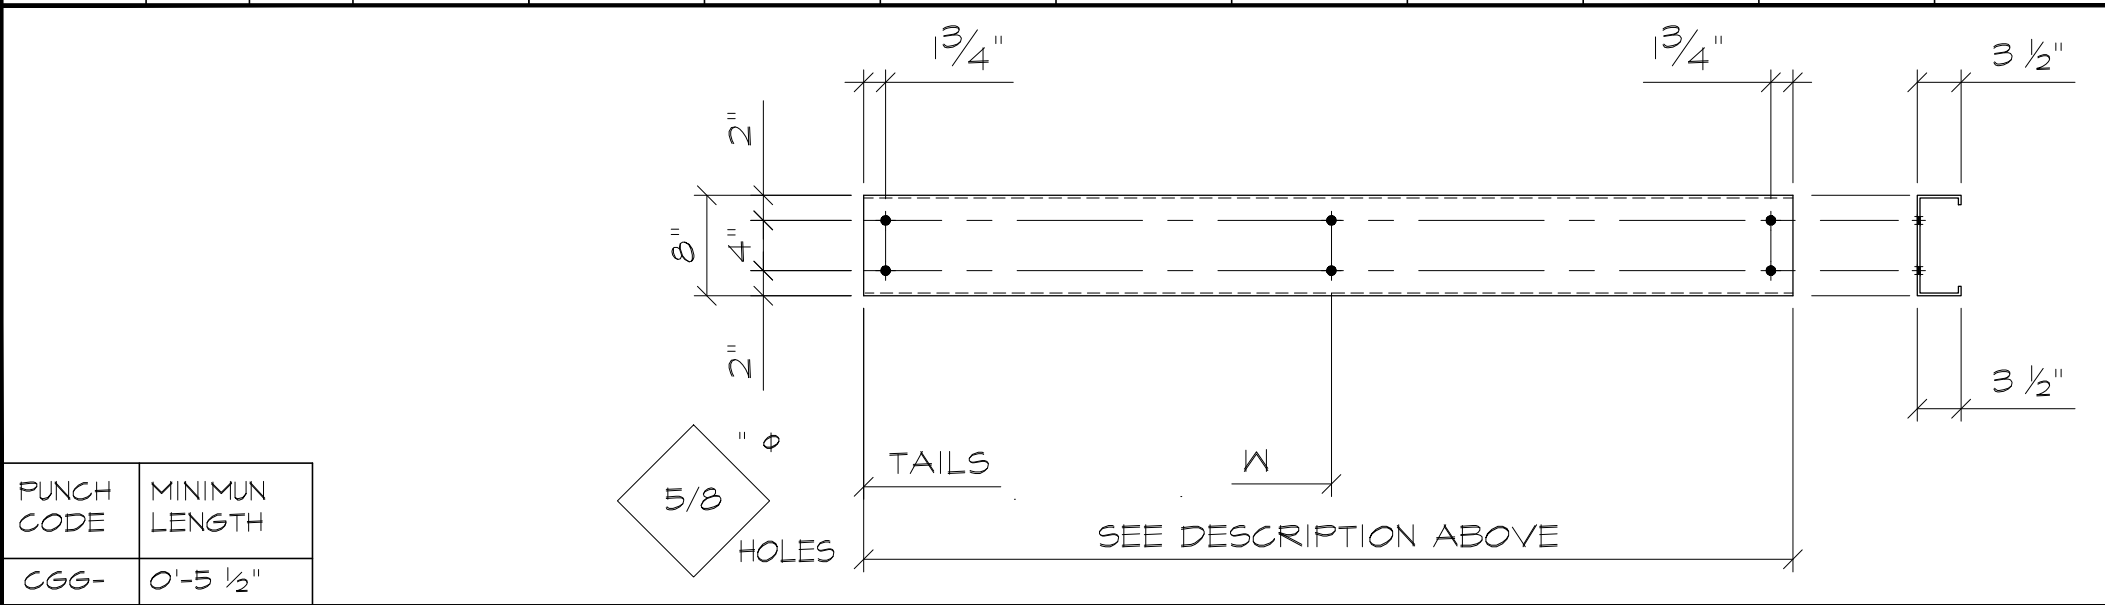



CAD FILE 3591-01BME15	PLOTTING SCALE 3/4" = 1'	SHEET NO. E15	JOB NO. 3591-01
DRAWN MLR	DATE 03/18/24	REVISION	
CHECKED VR	DATE 03/19/24	PHASE-II	


COLD FORM		FINISH: RED OXIDE					8C3½ x14GA					
QTY. RECIEVED	ITEM	QTY.	MARK	W	W1	W2	W3	W4	W5	W6	W7	LENGTH
	1 (+1)	3	CGG-150	1'-9 ¾"	5'-10"	7'-2 ¾"						11'-8"
	2	2	CGG-151									5'-1"
	3	6	CGG-152	2'-8 ¾"								3'-7 ¾"
	4	3	CGG-153									2'-7"
	5	2	CGG-154	1'-10 ¾"	5'-6"	8'-2 ¾"						11'-4"
	6											
	7	2	CGG-156	10 ¾"	3'-1 ¾"							5'-1 ¼"
	8	2	CGG-157	1'-2 ¼"	3'-1 ¾"							5'-1 ¼"
	9											
	10											

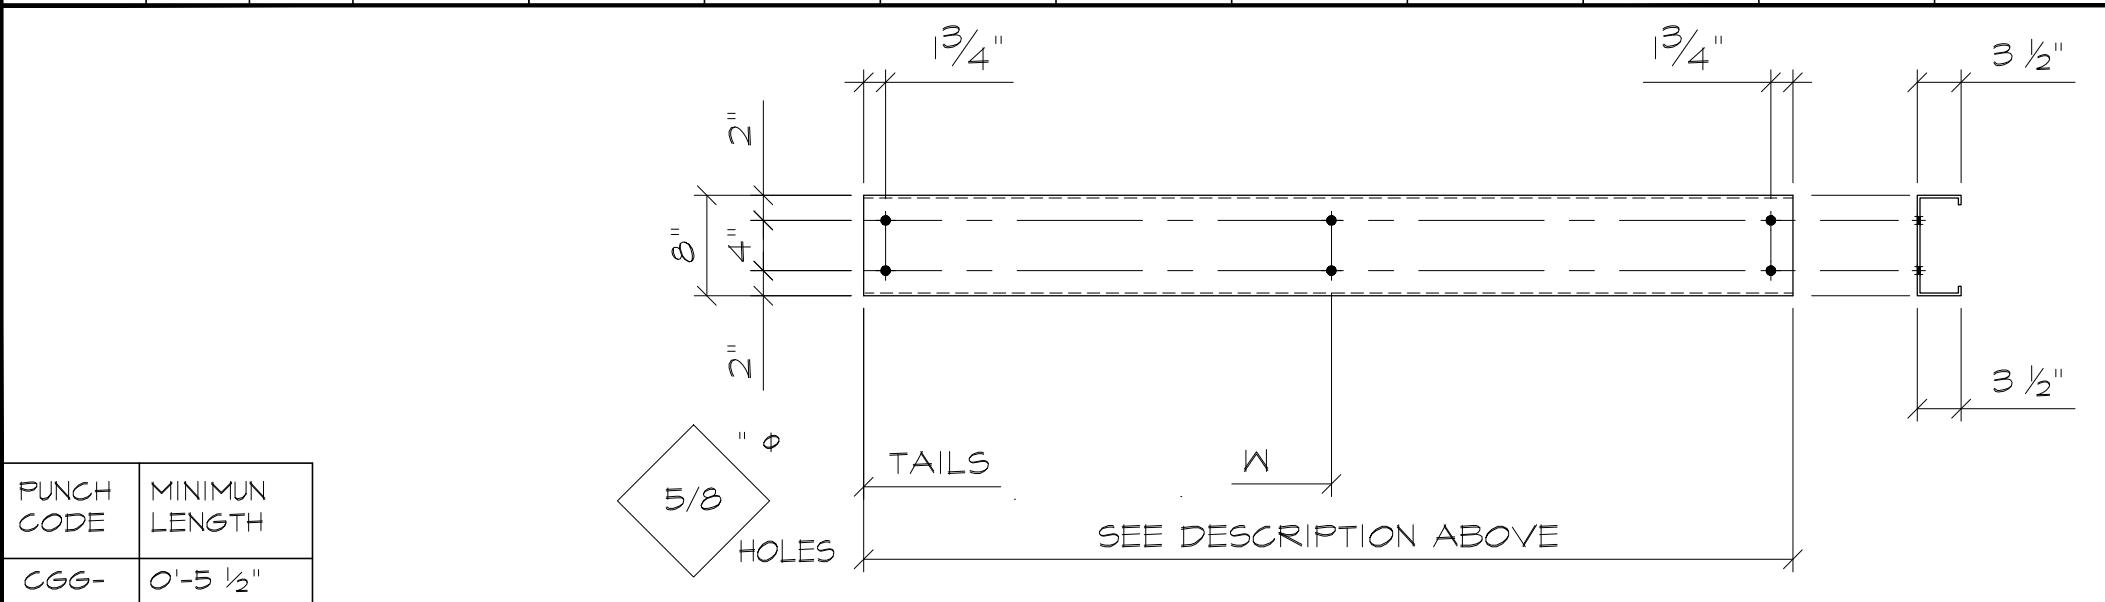



CAD FILE 3591-01BME16	PLOTTING SCALE 3/4" = 1'	SHEET NO. E16	JOB NO. 3591-01
DRAWN MLR	DATE 03/18/24	REVISION	
CHECKED VR	DATE 03/19/24	PHASE-II	

COLD FORM		FINISH: RED OXIDE					8C3½ x14GA					
QTY. RECIEVED	ITEM	QTY.	MARK	W	W1	W2	W3	W4	W5	W6	W7	LENGTH
	1	2	CGG-160		4'-3 ½"	5'-7 ½"	5'-10"	6'-3 ½"	7'-7 ½"			11'-4"
	2	4	CGG-161									3'-0"
	3	2	CGG-162	2'-4"	3'-8"							5'-4"
	4	2	CGG-163									2'-0"
	5											
	6											
	7											
	8											
	9											
	10											

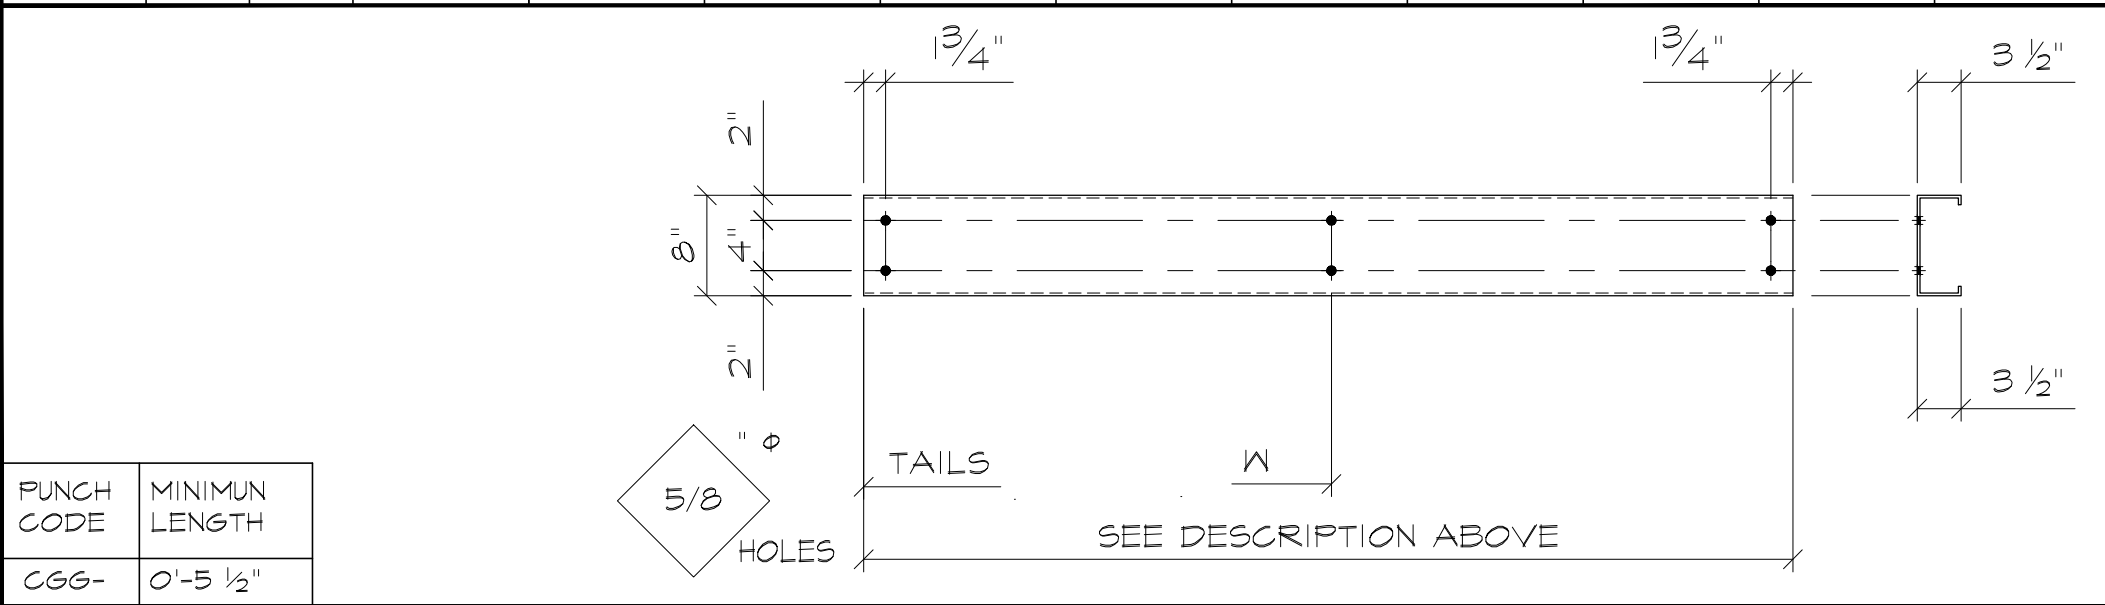



CAD FILE
3591-01BME17

PLOTTING SCALE
3/4" = 1'

SHEET NO.
E17

JOB NO.
3591-01

DRAWN
PSK

DATE
02/19/24

REVISION

CHECKED
BNB

DATE
02/19/24


PHASE-II

COLD FORM

FINISH: RED OXIDE

8C2½ x14GA

QTY. RECIEVED	ITEM	QTY.	MARK	W	W1	W2	W3	W4	W5	W6	W7	LENGTH
	1 (+1)	3	CGG-170	3'-3 ¾"								3'-7 ¾"
	2											
	3											
	4											
	5											
	6											
	7											
	8											
	9											
	10											

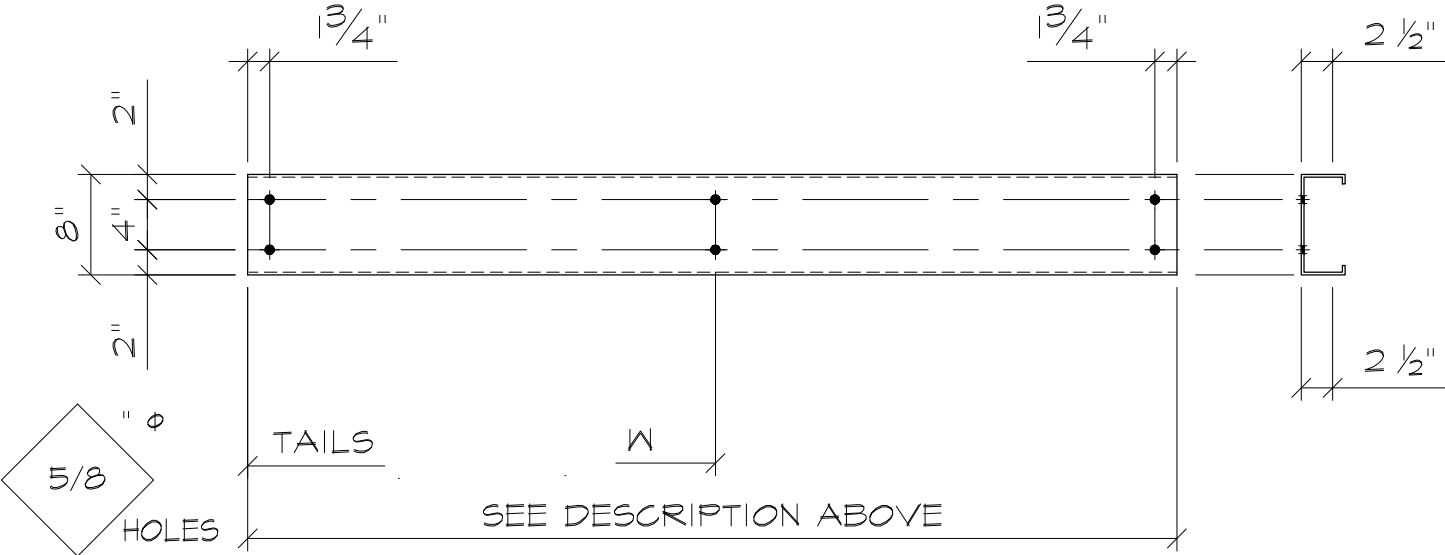


PUNCH CODE	MINIMUM LENGTH
CGG-	0'-5 ½"




CAD FILE 3591-01BME18	PLOTTING SCALE 1 = 1	SHEET NO. E18	JOB NO. 3591-01
DRAWN PSK	DATE 02/19/24	REVISION	
CHECKED BNB	DATE 02/19/24	PHASE-II	

QTY. RECIEVED	ITEM	QTY.	MARK	DESCRIPTION Title Packing List	LENGTH
	1			ROLLED COLD FORM SHOP	
	2			FINISH:RED OXIDE	
	3		SSL-10	(NCI) 10" STRUT SPACER LOW EAVE (10C3.5X16GA) SLOPE=	0'-6"
	4		SSL-12	(NCI) 12" STRUT SPACER LOW EAVE (12C3.5X16GA) SLOPE=	0'-6"
	5	176	GSI	GIRT SUPPORT CLIP(S) (L 7 x 3 x 16GA)	0'-6"
	6		SSH-10	(NCI) 10" STRUT SPACER HI. EAVE (10C3.5X16GA) SLOPE=	0'-6"
	7		SSH-12	(NCI) 12" STRUT SPACER HI. EAVE (12C3.5X16GA) SLOPE=	0'-6"
	8		GC-1	GIRT SUPPORT CLIP(S) (L7x3x16GA)	0'-6"
	9		GH8	(NCI) 8 1/4" GIRT HEADER (17 15/16" X 14GA)	
	10		GH10	(NCI) 10 1/4" GIRT HEADER (19 15/16" X 14GA)	
	11		GH12	(NCI) 12 1/4" GIRT HEADER (21 15/16" X 14GA)	
	12		SSI	PURLIN/GIRT STRUT SPACER(S) (8Z2 1/2 x 16GA)	0'-6"
	13		PM-1	EXT. SHEETING PLATE 5 15/16 X 16 GA. (NO HOLES NO BENDS)	6'-0"
	14	▶	SHOP NOTE: ALL 16GA. MIN. REQD. HEAVIER GA. COULD BE REPLACE PER STOCK.		
	15 (+1)		RA1	RAKE ANGLE(S) (L 4 x 2 x 16GA)	20'-0"
	16 (+1)	16	BC1	BASE CHANNEL(S) (8C2 1/2 x 16GA)	20'-0"
	17 (+1)		BC2	BASE CHANNEL(S) (10C2 1/2 x 16GA)	20'-0"
	18 (+1)		BC3	BASE CHANNEL(S) (12C2 1/2 x 16GA)	20'-0"
	19 (+1)	9	RA3	RAKE ANGLE(S) (L 6 x 4 x 16GA)	20'-0"
	20 (+1)		SA1	LINER RAKE ANGLE(S) (L 6 x 4 x 16GA)	20'-0"
	21 (+1)	10	SA2	LINER SUPPORT ANGLE(S) (L 5 x 3 x 16GA)	20'-0"
	22 (+1)		SA3	LINER EAVE ANGLE(S) (L 7 x 3 x 16GA) (FOR 10" GIRTS) (ANGLE=90 DEG)	20'-0"
	23 (+1)		VSP-1	VALLEY PLATE (15x15x16GA)	10'-0"
	24 (+1)	9	SA5	SHTG. ANGLE(S) (L 4 x 4 x 16GA)	20'-0"
	25 (+1)		SC-5	STD. BOLTED SHT. CLIPS (L 4 x 2 x 16GA) @ 8" GIRT	0'-7 1/2"
	26 (+1)		SC-54	STD. BOLTED SHT. CLIPS (L 4 x 2 x 16GA) @10" GIRT	0'-7 1/2"
	27 (+1)			STD. BOLTED SHT. CLIPS (L 6 x 2 x 16GA) @12" GIRT	0'-7 1/2"

	CAD FILE 3591-01BME19	PLOTTING SCALE 3/4" = 1'	SHEET NO. E19	JOB NO. 3591-01
	DRAWN MLR	DATE 03/18/24	REVISION	
	CHECKED VR	DATE 03/19/24	PHASE-II	

COLD FORM		FINISH: RED-OXIDE					8C2½ x 14GA					
QTY. RECIEVED	ITEM	QTY.	MARK	W	W1	W2	W3	W4	W5	W6	W7	LENGTH
	1 (+3)	12	CNP-190	(NO HOLES)								5'-8"
	2	59	CNP-191									5'-4"
	3	8	CNP-192									1'-0"
	4	3	CNP-193									3'-8"
	5	3	CNP-194									0'-11 3/4"
	6	6	CNP-195									3'-4"
	7	2	CNP-196									4'-4"
	8											
	9											
	10											

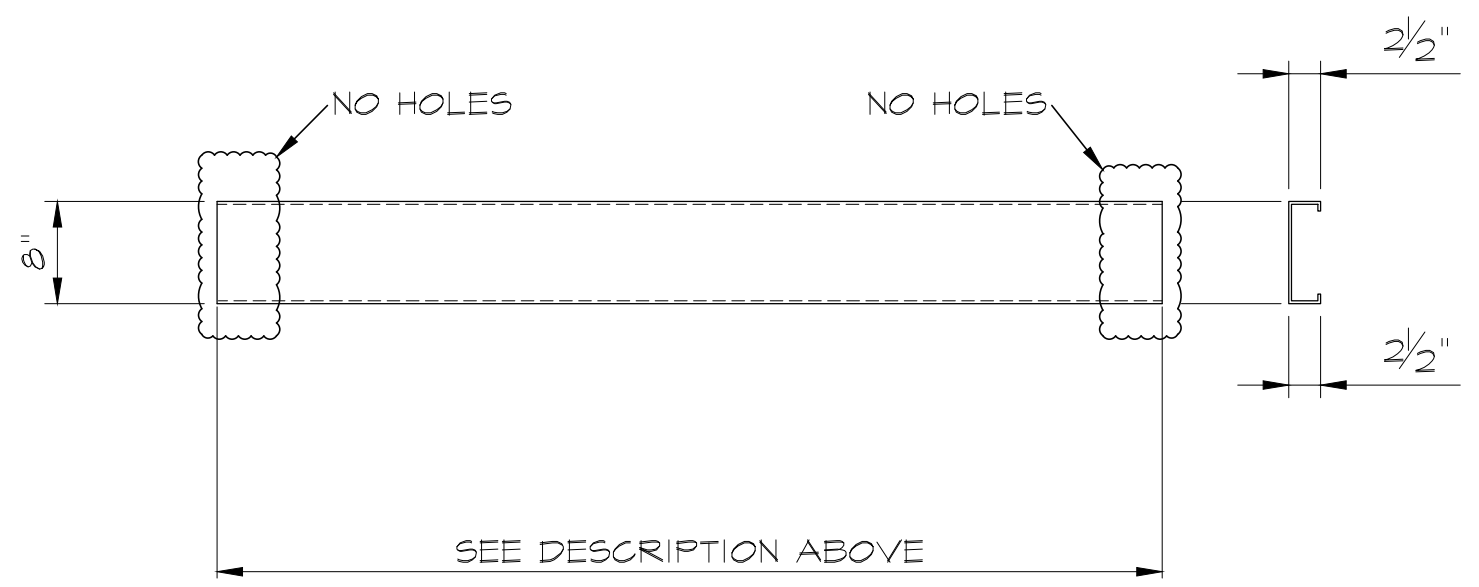


PUNCH CODE	MINIMUM LENGTH
CGG-	0'-5 ½"



CAD FILE 3591-01BME20	PLOTTING SCALE 3/4" = 1'	SHEET NO. E20	JOB NO. 3591-01
DRAWN MLR	DATE 03/18/24	REVISION	
CHECKED VR	DATE 03/19/24	PHASE-II	

COLD FORM		FINISH: RED OXIDE					8Z2½ x16GA					
QTY. RECIEVED	ITEM	QTY.	MARK	W	W1	W2	W3	W4	W5	W6	W7	LENGTH
	1	ONE	ZXX-200	8'-3 ¼"	11'-2 ¼"	19'-3 ¼"	22'-11 ¼"					27'-6"
	2	ONE	ZGX-201									19'-5 5/6"
	3	ONE	ZXG-202									14'-5 5/6"
	4	ONE	ZXS-203									22'-7 ¼"
	5	ONE	ZXX-204			15'-7 ¾"	21'-11 ¾"					27'-6"
	6	3	ZXS-205									22'-5"
	7	ONE	ZXG-206									10'-6 ¾"
	8											
	9											
	10											

Part No. ZGG-1		
LEADING PUNCH TAILING PUNCH		
PUNCH CODE	TOTAL LAP	MINIMUM LENGTH
ZGG-		0'-5 ½"
ZSS-	7 ½"	5'-5 ½"
ZLL-	2'-5 ½"	7'-3 ½"
ZXX-	4'-11 ½"	9'-9 ½"
ZUU-	6'-3 ½"	12'-5 ½"

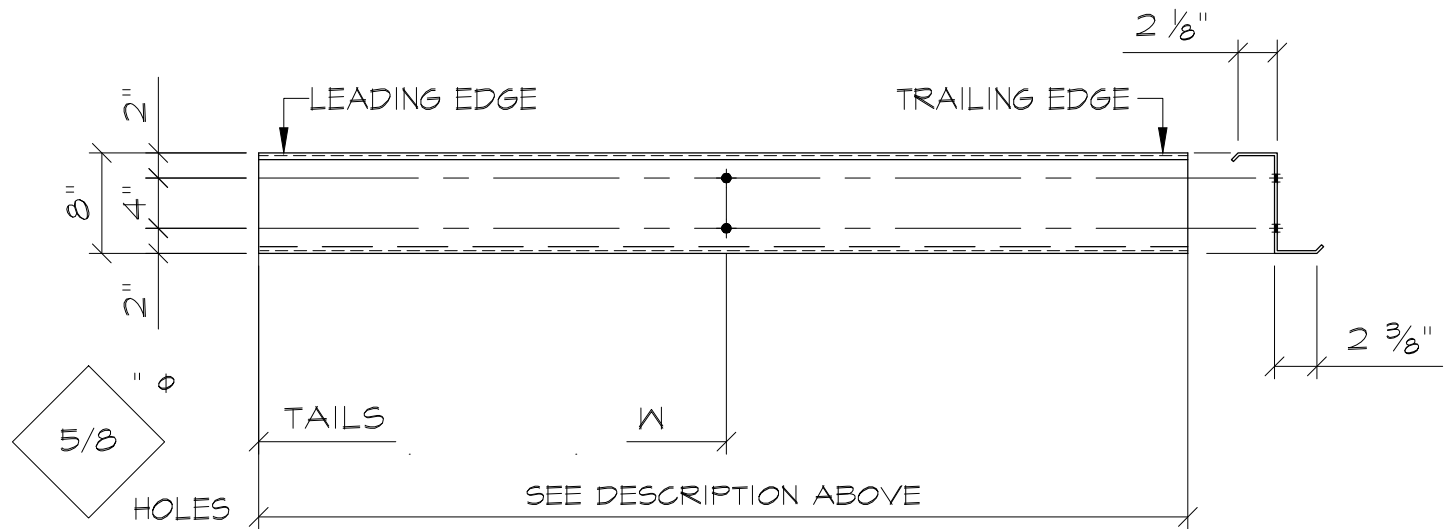








CAD FILE 3591-01BMFI	PLOTTING SCALE 1 = 1	SHEET NO. FI	JOB NO. 3591-01
DRAWN PSK	DATE 02/19/24	REVISION	
CHECKED BNB	DATE 02/19/24	PHASE-II	

QTY. RECIEVED	ITEM	QTY.	MARK	DESCRIPTION Title Packing List	COLOR	LENGTH
	1			ROOF SHEETING		
	2			22 GA., ULTRA-DEK PANELS		
	3			MINOR,MAS,PP,PN. (UL-90)		
	4					
	5 (+2)	86		ROOF (24" COVERAGE)	BRONZE FSC #26120	36'-6 1/2"
	6					
	7					
	8					
	9					
	10					
	11					
	12					
	13					
	14					
	15					
	16					
	17					
	18					
	19					
	20					
	21					
	22					
	23					
	24					
	25					
	26					
	27					



CAD FILE 3591-01BMF2	PLOTTING SCALE 1 = 1	SHEET NO. F2	JOB NO. 3591-01
DRAWN PSK	DATE 02/19/24	REVISION	
CHECKED BNB	DATE 02/19/24	PHASE-II	

QTY. RECIEVED	ITEM	QTY.	MARK	DESCRIPTION Title Packing List	COLOR	LENGTH
	1			EXTERIOR WALL SHEETING		
	2			22GA. "R" WALL PANELS (36" COVERAGE)		
	3	29		ELEVATION AT COL. LINE "D"	BEIGE FSC #36415	24'-2"
	4	29				14'-2"
	5					
	6 (+1)	3		ELEVATION AT COL. LINE "5"		26'-1"
	7	2				25'-5"
	8	2				24'-5"
	9	24				24'-2"
	10	2				23'-5"
	11	2				22'-5"
	12	2				21'-5"
	13	2				20'-5"
	14	2				19'-5"
	15	2				18'-5"
	16	2				17'-5"
	17	2				16'-5"
	18	2				15'-5"
	19					
	20	29		ELEVATION AT COL. LINE "A"		24'-2"
	21	29				14'-2"
	22					
	23					
	24					
	25					
	26					
	27					



CAD FILE 3591-01BMF3	PLOTTING SCALE 1 = 1	SHEET NO. F3	JOB NO. 3591-01
DRAWN PSK	DATE 02/19/24	REVISION	
CHECKED BNB	DATE 02/19/24	PHASE-II	

QTY. RECIEVED	ITEM	QTY.	MARK	DESCRIPTION Title Packing List	COLOR	LENGTH
	1			EXTERIOR WALL SHEETING		
	2			22GA. "R" WALL PANELS (36" COVERAGE)		
	3	2		ELEVATION AT COL. LINE "I"	BEIGE FSC #36415	26'-1"
	4	2				25'-5"
	5	2				24'-5"
	6	18				24'-2"
	7	2				23'-5"
	8	2				22'-5"
	9	2				21'-5"
	10	2				20'-5"
	11	2				19'-5"
	12	2				18'-5"
	13	2				17'-5"
	14	2				16'-5"
	15	2				15'-5"
	16	6				8'-1"
	17					
	18					
	19					
	20					
	21					
	22					
	23					
	24					
	25					
	26					
	27					



CAD FILE 359I-01BMF4	PLOTTING SCALE 1 = 1	SHEET NO. F4	JOB NO. 359I-01
DRAWN PSK	DATE 02/19/24	REVISION	
CHECKED BNB	DATE 02/19/24	PHASE-II	

QTY. RECIEVED	ITEM	QTY.	MARK	DESCRIPTION Title Packing List	COLOR	LENGTH
	1			ROOF LINER SHEETING	23% PERFORATED	
	2	64		26GA "C" ROOF PANEL (32" COVERAGE)	FLAT WHITE FSC #37875	19'-6"
	3	64		26GA "C" ROOF PANEL (32" COVERAGE)		16'-10"
	4			INTERIOR WALL SHEETING		
	5			26GA. "C" WALL PANELS (32" COVERAGE)		
	6 (+1)	3		ELEVATION AT COL. LINE "I"		25'-3"
	7	2				24'-4"
	8	2				24'-3"
	9	2				23'-5 1/2"
	10	2				22'-7"
	11	2				21'-8"
	12	2				20'-9 1/2"
	13	2				19'-11"
	14	2				19'-0"
	15	2				18'-1 1/2"
	16	2				17'-3"
	17	2				16'-4"
	18	2				15'-5 1/2"
	19	2				14'-7"
	20	5				5'-10"
	21					
	22	3		ELEVATION AT COL. LINE "D"		24'-3"
	23	3		ELEVATION AT COL. LINE "D"		13'-6 1/2"
	24					
	25					
	26					
	27					



CAD FILE 3591-01BMF5	PLOTTING SCALE 1 = 1	SHEET NO. F5	JOB NO. 3591-01
DRAWN MLR	DATE 03/18/24	REVISION	
CHECKED VR	DATE 03/19/24	PHASE-II	

QTY. RECIEVED	ITEM	QTY.	MARK	DESCRIPTION Title Packing List	COLOR	LENGTH
	1			INTERIOR WALL SHEETING	23% PERFORATED	
	2			26GA. "C" WALL PANELS (32" COVERAGE)		
	3	2		ELEVATION AT COL. LINE "5"	FLAT WHITE FSC #37875	25'-3"
	4	2				24'-4"
	5	26				24'-3"
	6	2				23'-5 1/2"
	7	2				22'-7"
	8	2				21'-8"
	9	2				20'-9 1/2"
	10	2				19'-11"
	11	2				19'-0"
	12	2				18'-1 1/2"
	13	2				17'-3"
	14	2				16'-4"
	15	2				15'-5 1/2"
	16	2				14'-7"
	17					
	18	32		ELEVATION AT COL. LINE "A"		24'-3"
	19	32		ELEVATION AT COL. LINE "A"		13'-6 1/2"
	20					
	21					
	22					
	23					
	24					
	26					
	27					



CAD FILE 3591-01BMGI	PLOTTING SCALE 1 = 1	SHEET NO. 61	JOB NO. 3591-01
DRAWN PSK	DATE 02/19/24	REVISION	
CHECKED BNB	DATE 02/19/24	PHASE-II	

QTY. RECIEVED	ITEM	QTY.	MARK	DESCRIPTION Title Packing List	COLOR	LENGTH
	1			22 GA. METAL TRIM FOR ULTRA-DEK		
	2			4/12 ROOF SLOPE U.N.		
	3	2	FL-126	PEAK BOX (TO MATCH FL-110) (4:12)	BRONZE FSC #26120	2'-6"
	4					
	5	12	FL-110	RAKE TRIM		10'-2"
	6	2	FL-110L	RAKE TRIM W/LF END MITER TO FL-240A		10'-2"
	7	2	FL-110R	RAKE TRIM W/RT END MITER TO FL-240A		10'-2"
	8	16	FL-115	RAKE SLIDE FLASHING (USE DROP AS NEEDED)		10'-2"
	9	12	FL-117	TERMINATION TRIM		14'-2"
	10					
	11	22	SF-10	SNOW RETENTION TRIM 2" WIDE x (HOLD DIM.)		8'-0"
	12	9	FL-207	RIDGE FLASHING 32"PK SP (4:12) USE DROP		10'-2"
	13	2	FL-201	RIDGE END CAP(TO MATCH FL-207 4:12)		
	14	6	RECX	RIDGE END CAP AT ROOF CURB		
	15					
	16					
	17					
	18					
	19					
	20					
	21					
	22					
	23					
	24					
	25					
	26					
	27					

SHOP
NOTE






CAD FILE 3591-01BMG2	PLOTTING SCALE 1 = 1	SHEET NO. 62	JOB NO. 3591-01
DRAWN PSK	DATE 02/19/24	REVISION	
CHECKED BNB	DATE 02/19/24	PHASE-II	

QTY. RECIEVED	ITEM	QTY.	MARK	DESCRIPTION Title Packing List	COLOR	LENGTH
	1			24 GA. METAL TRIM FOR ULTRA-DEK		
	2			4/12 ROOF SLOPE U.N.		
	3	7	FL-241A	EAVE GUTTER (4:12)	BRONZE FSC #26120	20'-2"
	4	2	FL-240A-R	GUTTER W/RT.END MITER TO FL-110 (4:12)		10'-2"
	5	2	FL-240A-L	GUTTER W/LF.END MITER TO FL-110 (4:12)		10'-2"
	6	2	FL-245R	GUTTER END CAP RIGHT (MATCH FL-240A 4:12)		
	7	2	FL-245L	GUTTER END CAP LEFT (MATCH FL-240A 4:12)		
	8	17	FL-271	OFFSET PANEL CAP TRIM (4:12)		10'-2"
	9					
	10	10	FL-31H	DOWNSPOUT STRAIGHT		20'-2"
	11	10	FL-31G	DOWNSPOUT W/ KICKOUT (45 DEG)		20'-2"
	12 (+2)	62	FL-797	DOWNSPOUT STRAPS (@ 7'-0" O/C)		0'-1"
	13					
	14					
	15					
	16					
	17					
	18					
	19					
	20					
	21					
	22					
	23					
	24					
	25					
	26					
	27					




CAD FILE 3591-01BMG3	PLOTTING SCALE 1 = 1	SHEET NO. 63	JOB NO. 3591-01
DRAWN MLR	DATE 03/18/24	REVISION	
CHECKED VR	DATE 03/19/24	PHASE-II	

QTY. RECIEVED	ITEM	QTY.	MARK	DESCRIPTION Title Packing List	COLOR	LENGTH
	1			22 GA. METAL TRIM FOR R PANELS		
	2			UNLESS NOTED		
	3					
	4		RBR	PEAK BOX ("R" PANEL)		2'-0"
	5		RBRX	PEAK BOX ("R" [PANEL)		2'-0"
	6		RBRV	PEAK BOX ("R" [PANEL) "B" =		2'-0"
	7		RBRVX	PEAK BOX ("R" [PANEL) "A" = "B" =		2'-0"
	8					
	9					
	10		RTR	RAKE TRIM		
	11		RTR	RAKE TRIM		
	12		R/L	RAKE TRIM ENDS TO FIT RTR		-
	13					
	14					
	15			EAVE TRIM		
	16			EAVE TRIM		
	17			EAVE TRIM ENDS TO FIT		-
	18					
	19	8	CTR	CORNER TRIM	BRONZE FSC #26120	19'-2"
	20		CTR	CORNER TRIM		
	21					
	22		CTR _X	CORNER TRIM "A" = "B" =		
	23					
	24	16	BTI	BASE TRIM "R" (USE DROP)	BIEGE FSC #36415	20'-2"
	25		BTI	BASE TRIM "R"		
	26		BTIX	BASE TRIM "A" =		
	27					




CAD FILE 3591-01BMG4	PLOTTING SCALE 1 = 1	SHEET NO. G4	JOB NO. 3591-01
DRAWN MLR	DATE 03/18/24	REVISION	
CHECKED VR	DATE 03/19/24	PHASE-II	

 QTY. RECIEVED	ITEM	QTY.	MARK	DESCRIPTION Title Packing List	COLOR		LENGTH
	1			22 GA. METAL TRIM (EXTERIOR WALL)			
	2						
	3 (+1)	2	HTR	HEAD TRIM	BIEGE FSC #36415		18'-6"
	4	ONE	HTR	HEAD TRIM			6'-6"
	5	ONE	HTR	HEAD TRIM			6'-0"
	6	ONE	HTR	HEAD TRIM			5'-7"
	7	6	HTR	HEAD TRIM			3'-10"
	8	4	HTR	HEAD TRIM			3'-7"
	9	3	HTR	HEAD TRIM			3'-0"
	10	2	HTR	HEAD TRIM			2'-6"
	11	2	HTR	HEAD TRIM			3'-6"
	12						
	13						
	14 (+1)	3	JTR	JAMB TRIM			16'-6"
	15	8	JTR	JAMB TRIM			7'-8"
	16	2	JTR	JAMB TRIM			6'-6"
	17	2	JTR	JAMB TRIM			6'-0"
	18	2	JTR	JAMB TRIM			5'-7"
	19	4	JTR	JAMB TRIM			3'-10"
	20	8	JTR	JAMB TRIM			3'-7"
	21	6	JTR	JAMB TRIM			3'-0"
	22	2	JTR	JAMB TRIM			2'-6"
	23	6	JTR	JAMB TRIM			1'-6"
	24						
	25						
	26		SF-IX	FLAT TRIM @ BEAM PENETRATIONS (8" WIDE)			
	27						




CAD FILE 3591-01BM65	PLOTTING SCALE 1 = 1	SHEET NO. 65	JOB NO. 3591-01
DRAWN MLR	DATE 03/18/24	REVISION	
CHECKED VR	DATE 03/19/24	PHASE-II	

QTY. RECIEVED	ITEM	QTY.	MARK	DESCRIPTION Title Packing List	COLOR		LENGTH
	1			22 GA. METAL TRIM (EXTERIOR WALL)			
	2						
	3 (+1)	2		SILL TRIM	BIEGE FSC #36415		6'-6"
	4	ONE	STR	SILL TRIM			6'-0"
	5	ONE	STR	SILL TRIM			5'-7"
	6	2	STR	SILL TRIM			3'-10"
	7	3	STR	SILL TRIM			3'-0"
	8	4	STR	SILL TRIM			3'-7"
	9	2	STR	SILL TRIM			2'-6"
	10	2	STR	SILL TRIM			3'-6"
	11						
	12						
	13	4	SF-1A	FLAT TRIM (@ PIPE FRAMED OPENING) 23"WIDE			3'-7"
	14	2	SF-2A	FLAT TRIM (@ PIPE FRAMED OPENING) 15"WIDE			2'-3"
	15		SF-3A				
	16						
	17	ONE	CTB	CHANNEL CLOSURE TRIM "A"=8 1/8" , "B"=3 1/2" & "C"=3 1/2"			18'-3"
	18	2	CTB	CHANNEL CLOSURE TRIM "A"=8 1/8" , "B"=2 1/4" & "C"=2 1/4"			16'-3"
	19						
	20						
	21						
	22						
	23						
	24						
	25						
	26						
	27						




CAD FILE 3591-01BM66	PLOTTING SCALE 1 = 1	SHEET NO. 66	JOB NO. 3591-01
DRAWN MLR	DATE 03/18/24	REVISION	
CHECKED VR	DATE 03/19/24	PHASE-II	

QTY. RECIEVED	ITEM	QTY.	MARK	DESCRIPTION Title Packing List	COLOR	LENGTH
	1			26GA. METAL TRIM (INTERIOR WALL)		
	2					
	3 (+1)	2	STRX	HEAD TRIM (A=1")	FLAT WHITE	6'-6"
	4	ONE	STRX	HEAD TRIM (A=1")	FSC #37875	6'-0"
	5	ONE	STRX	HEAD TRIM (A=1")		5'-7"
	6	6	STRX	HEAD TRIM (A=1")		3'-10"
	7	4	STRX	HEAD TRIM (A=1")		3'-7"
	8	3	STRX	HEAD TRIM (A=1")		3'-0"
	9	2	STRX	HEAD TRIM (A=1")		2'-6"
	10	2	STRX	HEAD TRIM (A=1")		3'-6"
	11					
	12 (+1)	3	STRX	JAMB TRIM (A=1")		18'-9"
	13	8	STRX	JAMB TRIM (A=1")		7'-8"
	14	2	STRX	JAMB TRIM (A=1")		6'-6"
	15	2	STRX	JAMB TRIM (A=1")		6'-0"
	16	2	STRX	JAMB TRIM (A=1")		5'-7"
	17	4	STRX	JAMB TRIM (A=1")		3'-10"
	18	8	STRX	JAMB TRIM (A=1")		3'-7"
	19	6	STRX	JAMB TRIM (A=1")		3'-0"
	20	2	STRX	JAMB TRIM (A=1")		2'-6"
	21	6	STRX	JAMB TRIM (A=1")		1'-6"
	22	12	STRX	JAMB TRIM @ ROOF EXHAUST FAN (A=1")		4'-0"
	23					
	24	10	LET	LINER EAVE TRIM [4 /12 SLOPE]		17'-2"
	25	9	LRR	LINER RIDGE ROLL TRIM [4 /12 SLOPE]		10'-2"
	26					
	27					



CAD FILE 3591-01BMG1	PLOTTING SCALE 1 = 1	SHEET NO. G7	JOB NO. 3591-01
DRAWN MLR	DATE 03/18/24	REVISION	
CHECKED VR	DATE 03/19/24	PHASE-II	

QTY. RECIEVED	ITEM	QTY.	MARK	DESCRIPTION Title Packing List	COLOR	LENGTH
	1			26GA. METAL TRIM (INTERIOR)		
	2					
	3 (+1)	2	STRX	SILL TRIM (A=1")	FLAT WHITE	6'-6"
	4	ONE	STRX	SILL TRIM (A=1")	FSC #37875	6'-0"
	5	ONE	STRX	SILL TRIM (A=1")		5'-7"
	6	2	STRX	SILL TRIM (A=1")		3'-10"
	7	3	STRX	SILL TRIM (A=1")		3'-0"
	8	4	STRX	SILL TRIM (A=1")		3'-7"
	9	2	STRX	SILL TRIM (A=1")		2'-6"
	10	2	STRX	SILL TRIM (A=1")		3'-6"
	11					
	12	4	SF-1B	FLAT TRIM (@ PIPE FRAMED OPENING) 23"WIDE		3'-7"
	13	2	SF-2B	FLAT TRIM (@ PIPE FRAMED OPENING) 15"WIDE		2'-3"
	14		SF-3B	FLAT TRIM (@ PIPE FRAMED OPENING) 9"WIDE		
	15					
	16	8	CTK	CORNER TRIM "A"=2" ; "B"=3"		7'-8"
	17	4	CTK	CORNER TRIM "A"=2" ; "B"=3"		3'-10"
	18					
	19	12	CTB	LINER CLOSURE TRIM "A"=8 1/4" , "B"=2" & "C"=2"		4'-0"
	20					
	21					
	22					
	23					
	24					
	25					
	26					
	27					



CAD FILE 3591-01BMHI	PLOTTING SCALE 1 = 1	SHEET NO. HI	JOB NO. 3591-01
DRAWN PSK	DATE 02/19/24	REVISION	
CHECKED BNB	DATE 02/19/24	PHASE-1	

QTY. RECIEVED	ITEM	QTY.	MARK	DESCRIPTION Title Packing List
	1			HARDWARE ITEMS ~ BOLTS
	2			FINISH: PLATED
	3			
	4			1"Φ x 3 3/4" A325 HI-STRENGTH BOLTS W/ HEAVY NUTS & WASHERS
	5			1"Φ x 3 1/2" A325 HI-STRENGTH BOLTS W/ HEAVY NUTS & WASHERS
	6			1"Φ x 3 1/4" A325 HI-STRENGTH BOLTS W/ HEAVY NUTS & WASHERS
	7			1"Φ x 3" A325 HI-STRENGTH BOLTS W/ HEAVY NUTS & WASHERS
	8			1"Φ x 2 3/4" A325 HI-STRENGTH BOLTS W/ HEAVY NUTS & WASHERS
	9			1"Φ x 2 1/2" A325 HI-STRENGTH BOLTS W/ HEAVY NUTS & WASHERS
	10			1"Φ x 2 1/4" A325 HI-STRENGTH BOLTS W/ HEAVY NUTS & WASHERS
	11			1"Φ x 2" A325 HI-STRENGTH BOLTS W/ HEAVY NUTS & WASHERS
	12			
	13			7/8"Φ x 3 1/2" A325 HI-STRENGTH BOLTS W/ HEAVY NUTS & WASHERS
	14			7/8"Φ x 3 1/4" A325 HI-STRENGTH BOLTS W/ HEAVY NUTS & WASHERS
	15			7/8"Φ x 3" A325 HI-STRENGTH BOLTS W/ HEAVY NUTS & WASHERS
	16			7/8"Φ x 2 3/4" A325 HI-STRENGTH BOLTS W/ HEAVY NUTS & WASHERS
	17			7/8"Φ x 2 1/2" A325 HI-STRENGTH BOLTS W/ HEAVY NUTS & WASHERS
	18			7/8"Φ x 2 1/4" A325 HI-STRENGTH BOLTS W/ HEAVY NUTS & WASHERS
	19 (+4)	68		7/8"Φ x 2" A325 HI-STRENGTH BOLTS W/ HEAVY NUTS & WASHERS
	20			
	21 (+6)	146		1 1/4"Ø x 4 1/2" A325 HI-STRENGTH BOLTS W/ HEAVY NUTS & WASHERS
	22			
	23			
	24			
	25			PINT TOUCH UP PAINT (ZRC)
	26			
	27			



CAD FILE 3591-01BMH2	PLOTTING SCALE 3/4" = 1	SHEET NO. H2	JOB NO. 3591-01
DRAWN PSK	DATE 02/19/24	REVISION	
CHECKED BNB	DATE 02/19/24	PHASE-1	

QTY. RECIEVED	ITEM	QTY.	MARK	DESCRIPTION Title Packing List
	1			HARDWARE ITEMS ~ BOLTS
	2			FINISH: PLATED
	3			
	4 (+2)	10		3/4"Φ x 2 3/4" A325 HI-STRENGTH BOLTS W/ (2)HEAVY NUTS & (2)WASHERS.(USE @E.W. COL. CONN.)
	5			3/4"Φ x 2 3/4" A325 HI-STRENGTH BOLTS W/ HEAVY NUTS & WASHERS.
	6 (+4)	92		3/4"Φ x 2 1/2" A325 HI-STRENGTH BOLTS W/ HEAVY NUTS & WASHERS.
	7 (+2)	34		3/4"Φ x 2 1/4" A325 HI-STRENGTH BOLTS W/ HEAVY NUTS & WASHERS
	8 (+2)	26		3/4"Φ x 2" A325 HI-STRENGTH BOLTS W/ HEAVY NUTS & WASHERS
	9			3/4"Φ x 1 3/4" A325 HI-STRENGTH BOLTS W/ HEAVY NUTS & WASHERS
	10			
	11			5/8"Φ x 2 3/4" A325 HI-STRENGTH BOLTS W/ HEAVY NUTS & WASHERS
	12 (+4)	92		5/8"Φ x 2 1/2" A325 HI-STRENGTH BOLTS W/ HEAVY NUTS & WASHERS
	13 (+4)	142		5/8"Φ x 2 1/4" A325 HI-STRENGTH BOLTS W/ HEAVY NUTS & WASHERS
	14 (+4)	70		5/8"Φ x 2" A325 HI-STRENGTH BOLTS W/ HEAVY NUTS & WASHERS
	15 (+18)	268		5/8"Φ x 1 3/4" A325 HI-STRENGTH BOLTS W/ HEAVY NUTS & WASHERS
	16			5/8"Φ x 1 1/2" A325 HI-STRENGTH BOLTS W/ HEAVY NUTS & WASHERS
	17			1/2"Φ x 2" A325 HI-STRENGTH BOLTS W/ HEAVY NUTS & WASHERS @ HEATER BRACKETS
	18			1/2"Φ x 1 3/4" A325 HI-STRENGTH BOLTS W/ HEAVY NUTS & WASHERS (@ HOSE TRAY)
	19			1/2"Φ x 1 1/2" A325 HI-STRENGTH BOLTS W/ HEAVY NUTS & WASHERS @ FAN BRACE
	20 (+16)	384		1/2"Φ x 1 1/4" A325 HI-STRENGTH BOLTS W/ HEAVY NUTS & WASHERS AT FLANGE BRACES
	21			
	22	ONE		PINTS TOUCH UP PAINT (ZRC)
	23			
	24 (10%)	180		1/2"Φ x 1 1/4" BUTTON HEAD BOLTS W/ NUTS
	25			
	26			
	27			3/8"Φ x 1" A307 MACHINE BOLTS W/ NUTS & WASHERS (FOR STAIR TREADS & HEATERS)



CAD FILE 3591-01BMH3	PLOTTING SCALE 3/4" = 1	SHEET NO. H3	JOB NO. 3591-01
DRAWN PSK	DATE 02/19/24	REVISION	
CHECKED BNB	DATE 02/19/24	PHASE-III	

QTY. RECIEVED	ITEM	QTY.	MARK	DESCRIPTION Title Packing List
	1			HARDWARE ITEMS ~ BOLTS
	2			FINISH: GALVANIZED
	3			
	4			3/4"Φ x 2 3/4" A325 HI-STRENGTH BOLTS W/ (2)HEAVY NUTS & (2)WASHERS.(USE @E.W. COL. CONN.)
	5			3/4"Φ x 2 3/4" A325 HI-STRENGTH BOLTS W/ HEAVY NUTS & WASHERS.
	6			3/4"Φ x 2 1/2" A325 HI-STRENGTH BOLTS W/ HEAVY NUTS & WASHERS.
	7			3/4"Φ x 2 1/4" A325 HI-STRENGTH BOLTS W/ HEAVY NUTS & WASHERS
	8 (+2)	34		3/4"Φ x 2" A325 HI-STRENGTH BOLTS W/ HEAVY NUTS & WASHERS
	9			3/4"Φ x 1 3/4" A325 HI-STRENGTH BOLTS W/ HEAVY NUTS & WASHERS
	10			
	11			5/8"Φ x 2 3/4" A325 HI-STRENGTH BOLTS W/ HEAVY NUTS & WASHERS
	12 (+2)	38		5/8"Φ x 2 1/2" A325 HI-STRENGTH BOLTS W/ HEAVY NUTS & WASHERS
	13 (+2)	32		5/8"Φ x 2 1/4" A325 HI-STRENGTH BOLTS W/ HEAVY NUTS & WASHERS
	14 (+2)	14		5/8"Φ x 2" A325 HI-STRENGTH BOLTS W/ HEAVY NUTS & WASHERS
	15 (+4)	133		5/8"Φ x 1 3/4" A325 HI-STRENGTH BOLTS W/ HEAVY NUTS & WASHERS
	16			5/8"Φ x 1 1/2" A325 HI-STRENGTH BOLTS W/ HEAVY NUTS & WASHERS
	17			1/2"Φ x 2" A325 HI-STRENGTH BOLTS W/ HEAVY NUTS & WASHERS @ HEATER BRACKETS
	18			1/2"Ø x 1 3/4" A325 HI-STRENGTH BOLTS W/ HEAVY NUTS & WASHERS (@ HOSE TRAY)
	19			1/2"Ø x 1 1/2" A325 HI-STRENGTH BOLTS W/ HEAVY NUTS & WASHERS (@ PIPE SUPPORT)
	20			1/2"Φ x 1 1/4" A325 HI-STRENGTH BOLTS W/ HEAVY NUTS & WASHERS AT FLANGE BRACES
	21			
	22			PINTS TOUCH UP PAINT (ZRC)
	23			
	24			1/2"Φ x 1 1/4" BUTTON HEAD BOLTS W/ NUTS
	25			
	26			
	27			3/8"Φ x 1" A307 MACHINE BOLTS W/ NUTS & WASHERS (FOR STAIR TREADS & HEATERS)



CAD FILE 3591-01BMH4	PLOTTING SCALE 1 = 1	SHEET NO. H4	JOB NO. 3591-01
DRAWN PSK	DATE 02/19/24	REVISION	
CHECKED BNB	DATE 02/19/24	PHASE-1	

QTY. RECIEVED	ITEM	QTY.	MARK	DESCRIPTION Title Packing List
	1			HARDWARE ITEMS (NUTS & WASHERS FOR A. BOLTS)
	2			
	3			1 1/4" FLAT WASHERS (FOR ANCHOR BOLTS)
	4			1" FLAT WASHERS (FOR ANCHOR BOLTS)
	5			3/4" FLAT WASHERS (FOR ANCHOR BOLTS)
	6			5/8" FLAT WASHERS (FOR ANCHOR BOLTS)
	7			1/2" FLAT WASHERS (FOR ANCHOR BOLTS)
	8			
	9			
	10			1 1/4" NUTS (FOR ANCHOR BOLTS)
	11			1" NUTS (FOR ANCHOR BOLTS)
	12			3/4" NUTS (FOR ANCHOR BOLTS)
	13			5/8" NUTS (FOR ANCHOR BOLTS)
	14			1/2" NUTS (FOR ANCHOR BOLTS)
	15			
	16	2		3/4"Φ x 0'-4 1/4" KWIK BOLTS
	17 (+2)	38		5/8"Φ x 0'-4 1/4" KWIK BOLTS
	18			
	19 (+2)	65		1/4"Φ x 0'-2" DRIVE-PINS (@ 5'-0" O.C.)
	20			
	21			
	22			3/4"Φ x 0'-10" HILTI HVU ADHESIVE ANCHOR SYS., W/ 3/4" x 0'-6 5/8" CARTRIDGE.
	23			5/8"Φ x 0'-8" HILTI HVU ADHESIVE ANCHOR SYS., W/ 5/8" x 0'-5" CARTRIDGE.
	24			
	25			
	26			7/8"Φ DRILL-COR BITS FOR 3/4"Φ HILTI ANCHORS (SUPPLIED BY ERECTOR)
	27			11/16"Φ DRILL-COR BITS FOR 5/8"Φ HILTI ANCHORS (SUPPLIED BY ERECTOR)



CAD FILE 3591-01BMH5	PLOTTING SCALE 1 = 1	SHEET NO. H5	JOB NO. 3591-01
DRAWN PSK	DATE 02/14/24	REVISION	
CHECKED BNB	DATE 02/19/24	PHASE-I	

QTY. RECIEVED	ITEM	QTY.	MARK	DESCRIPTION
	1			HARDWARE ITEMS (NUTS AND WASHERS)
	2			FINISH: PLATED
	3 (+1)			1/4" HILLSIDE WASHERS
	4 (+1)			1" HILLSIDE WASHERS
	5 (+1)	17		3/4" HILLSIDE WASHERS
	6 (+1)	17		5/8" HILLSIDE WASHERS
	7 (+1)	17		1/2" HILLSIDE WASHERS
	8			1/4" FLAT WASHERS
	9 (+2)			1" FLAT WASHERS
	10 (+2)	18		3/4" FLAT WASHERS
	11 (+2)	18		5/8" FLAT WASHERS
	12 (+2)	18		1/2" FLAT WASHERS
	13			1/4" NUTS
	14 (+2)			1" NUTS
	15 (+2)	18		3/4" NUTS
	16 (+2)	18		5/8" NUTS
	17 (+2)	18		1/2" NUTS
	18 (+2)			3/4" FLAT WASHERS AT CRANE
	19 (+2)			3/4" NUTS AT CRANE
	20 (+2)			3/4" BEVEL WASHERS AT CRANE
	21			
	22 (+2)			1" BEVEL WASHERS
	23 (+2)			3/4" BEVEL WASHERS
	24 (+2)			5/8" BEVEL WASHERS
	25 (+2)			1/2" BEVEL WASHERS
	26			1/2" NUTS (#13 THREADS FOR HEATER SUPP. RODS)
	27			DETAILER NOTE: CHECK WITH HEATER SPEC. FOR ROD SIZE & THREAD REQD.



CAD FILE 3591-01BMH6	PLOTTING SCALE 1 = 1	SHEET NO. H6	JOB NO. 3591-01
DRAWN PSK	DATE 02/19/24	REVISION	
CHECKED BNB	DATE 02/19/24	PHASE-I	

QTY. RECIEVED	ITEM	QTY.	MARK	DESCRIPTION Title Packing List	LENGTH
	1			HARDWARE ITEMS ~ BOLTS	
	2			FINISH PAINT: AS NTD.	
	3			<u>20'-0" CANOPIES</u>	
	4	26	GALV.	3/4"φ A307 NUTS FOR 3/4"φ THREADED RODS (4 PER RODS + 2)	
	5	26	GALV.	3/4"φ A307 WASHERS FOR 3/4"φ THREADED RODS (4 PER RODS + 2)	
	6	44	GALV.	1/2"φ x 1 1/4" A325 BOLTS W/ HEAVY WASHERS ONLY (7 PER RODS + 2)	
	7				
	8			<u>6'-0" CANOPIES</u>	
	9	34	GALV.	3/4"φ A307 NUTS FOR 3/4"φ THREADED RODS (4 PER RODS + 2)	
	10	34	GALV.	3/4"φ A307 WASHERS FOR 3/4"φ THREADED RODS (4 PER RODS + 2)	
	11	58	GALV.	1/2"φ x 1 1/4" A325 BOLTS W/ HEAVY WASHERS ONLY (7 PER RODS + 2)	
	12				
	14			<u>LADDER</u>	
	15 (+2)	15	PLATED	5/8"φ x 1 3/4" A325 BOLTS W/ HEAVY NUTS & WASHERS (ANGLE HANDRAILS)	
	16 (+2)	6	PLATED	5/8"φ x 1 3/4" A325 BOLTS W/ HEAVY NUTS & WASHERS (LADDER TO PLATFORM)	
	17 (+2)	4	PLATED	5/8"φ x 2" A325 BOLTS W/ HEAVY NUTS & WASHERS (ANGLES)	
	18				
	19				
	21			<u>STAIR TREADS & HEATERS</u>	
	22 (+2)			3/8"φ x 1" A307 MACHINE BOLTS W/ NUTS & WASHERS	
	24			<u>FANS</u>	
	25 (+2)			1/2"φ x 1/2" A325 BOLTS W/ (1) NUT & (2) WASHERS	
	26 (+10%)	2150	PLATED	1/2"φ x 1 1/4" A307 MACHINE BOLTS W/ NUTS	
	27 (+5%)	1210	PLATED	1/2" FLAT WASHERS FOR A307 BOLTS (USED AT SLOTTED CLIPS. INCLUDING WELD CLIP W/SLOTS)	



CAD FILE 3591-01BMH7	PLOTTING SCALE 1 = 1	SHEET NO. H7	JOB NO. 3591-01
DRAWN MLR	DATE 03/18/24	REVISION	
CHECKED VR	DATE 03/19/24	PHASE-II	

QTY. RECIEVED	ITEM	QTY.	MARK	DESCRIPTION Title Packing List
	1			HARDWARE ITEMS
	2			CLOSURES, TAPE SEALERS, TOUCH UP PAINT AND CAULK
	3 (+5)	53	HW-456	PIECES OF CLOSURE STRIP [OUTSIDE] TO FIT "PBR" PANEL PROFILE.
	4 (+5)	170	HW-455	PIECES OF CLOSURE STRIP [INSIDE] TO FIT "PBR" PANEL PROFILE.
	5			
	6			PIECES OF CLOSURE STRIP [OUTSIDE] TO FIT "" PANEL PROFILE.
	7			PIECES OF CLOSURE STRIP [INSIDE] TO FIT "" PANEL PROFILE.
	8			
	9			45' ROLLS OF ROPE SEAL
	10			
	11			LIN. FT. OF 1 1/2" - 2" ISOLATION TAPE (STICKY ONE SIDE)
	12			(USED BETWEEN STL. MEMBERS & ALUMINUM PANELS)
	13			
	14	50		50' ROLLS OF 1/8" x 1" - 2" ~ "STICKER - TITE" SOUND ATTENUATION TAPE
	15			
	16	ONE	(2 OZ.)	TOUCH UP PAINT (BRONZE FSC #26120)
	17	ONE	(2 OZ.)	TOUCH UP PAINT (BIEGE FSC #36415)
	18	ONE	(2 OZ.)	TOUCH UP PAINT (FLAT WHITE FSC #37875)
	19	ONE	PINT	TOUCH UP PAINT (RED OXIDE)
	20	16	61351	TUBES OF TITEBOND SEALANT [BRONZE FSC #26120] FOR TRIM & GEN. USE
	21	8	61611	TUBES OF TITEBOND SEALANT [BIEGE FSC #36415] FOR TRIM & GEN. USE
	22	6	61001	TUBES OF TITEBOND SEALANT [FLAT WHITE FSC #37875] FOR TRIM & GEN. USE
	23			
	24			TUBES OF URETHANE SEALANT [WHITE] USE FOR U.D./S.S. ROOF ONLY
	25			TUBES OF URETHANE SEALANT [GRAY]
	26	10	HW-542	TUBES OF URETHANE SEALANT [BRONZE]
	27			TUBES OF URETHANE SEALANT [ALMOND]



CAD FILE 3591-01BMH8	PLOTTING SCALE 1 = 1	SHEET NO. H8	JOB NO. 3591-01
DRAWN PSK	DATE 02/19/24	REVISION	
CHECKED BNB	DATE 02/19/24	PHASE-II	

QTY. RECIEVED	ITEM	QTY.	MARK	DESCRIPTION Title Packing List	COLOR
	1			HARDWARE ITEMS	
	2			SCREWS, UPLIFT STRAPS, POP RIVETS & GROMMETS	
(+ ³ 25%)	250	Fastener #6	#12 - 24 x 1 1/4" TEK 4.5 WITH WASHER	(STRUCTURAL SCREW)	PLAIN
(+ ⁴ 25%)	250	Fastener #6	#12 - 24 x 1 1/4" TEK 4.5 WITH WASHER	(STRUCTURAL SCREW) FLAT WHITE FSC #37875	
	5				
(+ ⁶ 25%)	4750	WALL	12-14 x 1" SELF - DRILLING SCREWS WITH WASHER		BEIGE FSC #36415
(+ ⁷ 25%)	3500	WALL	#14 x 7/8" LAP - TEK SCREWS WITH WASHER		BEIGE FSC #36415
	8				
(+ ⁹ 25%)	6350	LINER	12-14 x 1" SELF - DRILLING SCREWS WITH WASHER	FLAT WHITE FSC #37875	
	10	LINER	#14 x 7/8" LAP - TEK SCREWS WITH WASHER		
(+ ¹³ 25%)	750	STRAP	#12 x 1" SELF - DRILLING SCREWS WITH WASHER (FOR UPLIFT STRAPS)		PLAIN
(+ ¹⁴ 25%)	1000	WALLS TRIM	#14 x 7/8" LAP - TEK SCREWS WITH WASHER	BRONZE FSC #26120	
(+ ¹⁵ 25%)	750	LINER TRIM	#14 x 7/8" LAP - TEK SCREWS WITH WASHER	FLAT WHITE FSC # 37875	
			RIGID BOARD INSULATION FASTENER		
	16				
	17	6SI	#12 x 1" SELF - DRILLING SCREWS WITH WASHER		PLAIN
(+ ¹⁸ 25%)	500	ANGLE	#12 x 1" SELF - DRILLING SCREWS WITH WASHER		PLAIN
(+ ¹⁹ 25%)	250	#12	#10 x 1" #12 PHILLIPS PANCAKE HEAD DRILLER		PLAIN
	20		(USE @ STEEL/STEEL TO AVOID FOULING PNL.)		
	21	2	PEAK SIGNS		
	22	2	894 LIN FT. X24 GA. x 2" UPLIFT STRAPS (500'-0" ROLL)		GALVALUME
(+ ²³ 25%)	500		POP RIVETS		BRONZE FSC #26120
(+ ²⁴ 25%)	500		POP RIVETS	FLAT WHITE FSC #37875	
(+ ²⁵ 25%)			POP RIVETS		
	26		1/4" x 1" GROMMETS (FOR TRANSLUCENT PANEL SIDE LAPS)		
	27				



CAD FILE 3591-01BMH9	PLOTTING SCALE 1 = 1	SHEET NO. H9	JOB NO. 3591-01
DRAWN PSK	DATE 02/19/24	REVISION	
CHECKED BNB	DATE 02/19/24	PHASE-II	

QTY. RECIEVED	ITEM	QTY.	MARK	DESCRIPTION Title Packing List	COLOR
	1			HARDWARE ITEMS FOR ULTRA-DEK ROOF	
	2		Fastener #142	1/4" - 14 x 1 1/2" SELF DRILER	PLAIN
(+25%)	2750		Fastener #1	12 - 14 x 1" SELF DRILER	PLAIN
	4				
(+25%)	2500		Fastener #1E	1/4" - 14 x 1 1/4" LONG LIFE DRILLER WITH WASHER (ZAC)	BRONZE FSC #26120
	6				
	7		Fastener #1E	1/4" - 14 x 1 1/4" LONG LIFE DRILLER WITH WASHER (ZAC)	
	8				
(+25%)			Fastener #1F	1/4" - 14 x 1 1/2" LONG LIFE DRILLER WITH WASHER (ZAC)	
	10				
(+25%)	1500		Fastener #4	#1/4" - 14 x 7/8" LONG LIFE LAP TEK WITH WASHER (ZAC)	BRONZE FSC #26120
	12				
	13		Fastener #4	#1/4" - 14 x 7/8" LONG LIFE LAP TEK WITH WASHER (ZAC)	
	14				
(+25%)	500		Fastener #5	1/4" - 14 x 1 1/4" SHOULDER TEK 2 WITHOUT WASHER	PLAIN
	16			(FLOATING SYSTEMS ONLY)	
(+25%)	250		Fastener #2A	174 X1" TYPE AB LONG LIFE W / WASHER	BRONZE FSC #26120
(+25%)	250		Fastener #6	#12 - 24 x 1 1/4" TEK 4.5 WITH WASHER(HOT ROLL BEAM)	PLAIN
	19			(FIXED SYSTEMS ONLY)	
	20				
	21		Fastener #7	1/4" - 20 x 1 1/4" SHOULDER TEK 4 WITHOUT WASHER	PLAIN
	22			(FLOATING SYSTEMS ONLY)	
	23		Fastener #12	#10 x 1", #2 PHILLIPS PANCAKE HEAD DRILLER	PLAIN
(+25%)	250		Fastener #12A	#12 x 1", #2 PHILLIPS PANCAKE HEAD DRILLER	PLAIN
(+25%)	750		Fastener #14	1/8" x 3/16" POP RIVET	BRONZE FSC #26120
	26		Fastener #43	1/4" - 14 x 1 1/4" SELF DRILLER WITH WASHER	ROOF COLOR
	27				




CAD FILE 3591-01BMH10	PLOTTING SCALE 1 = 1	SHEET NO. H10	JOB NO. 3591-01
DRAWN MLR	DATE 03/18/24	REVISION	
CHECKED VR	DATE 03/19/24	PHASE-II	

QTY. RECIEVED	ITEM	QTY.	MARK	DESCRIPTION Title Packing List	COLOR	LENGTH
	1			HARDWARE ITEMS FOR ULTRA-DEK ROOF		
	2					
	3 (+4)	1000	HW-2102	LOW FLOATING CLIP	STANDARD	
	4					
	5					
	6 (+1)	23	HW-7600	LOW EAVE PLATE [14 GA.]	RED OXIDE	8'-0"
	7					
	8					
	9 (+1)	16	HW-7710	LOW RAKE SUPPORT (FLOATING) [14 GA.]	RED OXIDE	20'-0"
	10					
	11 (+1)	7	HW-7630	LOW FIXED PLATE [14 GA.]	RED OXIDE	10'-0"
	12					
	13 (+2)	88	HW-7760	24" BACK-UP PLATE [16 GA]	RED OXIDE	2'-0"
	14 (+2)	88	HW-430	24" OUTSIDE METAL CLOSURE [24 GA]	BRONZE FSC #26120	2'-0"
	15					
	16					
	17 (+2)	980	HW-577	3/8" THERMAL SPACER		1'-11 7/8"
	18 (+2)	86	FL-246	GUTTER SUPPORT CLIPS (@ 2'-0" O.C.) [18 GA.]	BRONZE FSC #26120	0'-10"
	19					
	20 (+4)	88	HW-426	METAL INSIDE CLOSURE [18 GA.]	GALVALUME	0'-4"
	21	2	HW-512	MINOR RIB TAPE SEALER (144 PIECES PER CARTON)	STD.	0'-4"
	22					
	23	7	HW-504	TRI-BEADTAPE SEAL ROLLS(7/8"X 3/16") (8 PER CARTON)	STANDARD	200'-0"
	24		HW-568	S-5 WIND CLAMP		
	25	ONE	HW-502	TRIPAL-BEAD TAPE SEAL ROLLS(3/16"X 2 7/8") (6 PER CARTON)	STD.	120'-0"
	26					
	27	ONE		ERECTION PACKAGE		



CAD FILE 3591-01BMJI	PLOTTING SCALE 1 1/2" = 1'	SHEET NO. JI	JOB NO. 3591-01
DRAWN PSK	DATE 02/19/24	REVISION	
CHECKED BNB	DATE 02/19/24	PHASE-IV	

QTY. RECIEVED	ITEM	QTY.	MARK	DESCRIPTION
	1			FINISH= BLACK; SPECIAL PAINT BY OTHERS
	2			SAFETY YELLOW
	3	ONE		1" X 3/16" GRATING WITH (4) SADDLE CLIPS
	4			
	5			
	6			
	7			

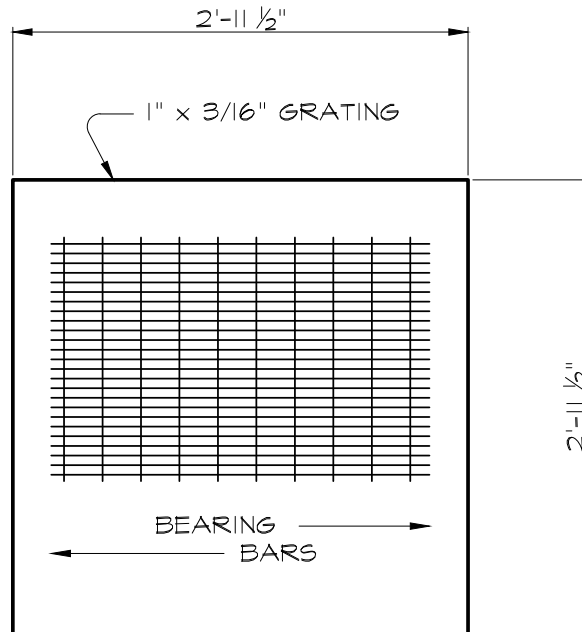


GRATING DETAIL



CAD FILE 3591-01BMJ2	PLOTTING SCALE 1 1/2" = 1'	SHEET NO. J2	JOB NO. 3591-01
DRAWN PSK	DATE 02/19/24	REVISION	
CHECKED BNB	DATE 02/19/24	PHASE-1	

QTY. RECIEVED	ITEM	QTY.	MARK	DESCRIPTION
	1			ACCESSORIES (CRANE RAIL)
	2			
	3	2	RUNS	60# A.S.C.E. RAIL x 76'-5 7/8" PUNCHED FOR HOOK BOLTS
	4			W/ NECESSARY SPLICE BARS AND BOLTS.
	5			
	6			SPLICE BARS & BOLTS REQD. (FOR TIE TO EXIST. RAIL)
	7			
	8		HBI	DIA HOOK BOLTS FOR RAIL TO FIT CAP
	9			
	10 (+2)	154	HBI	3/4" DIA HOOK BOLTS FOR 60# RAIL TO FIT C10X15.3 CAP

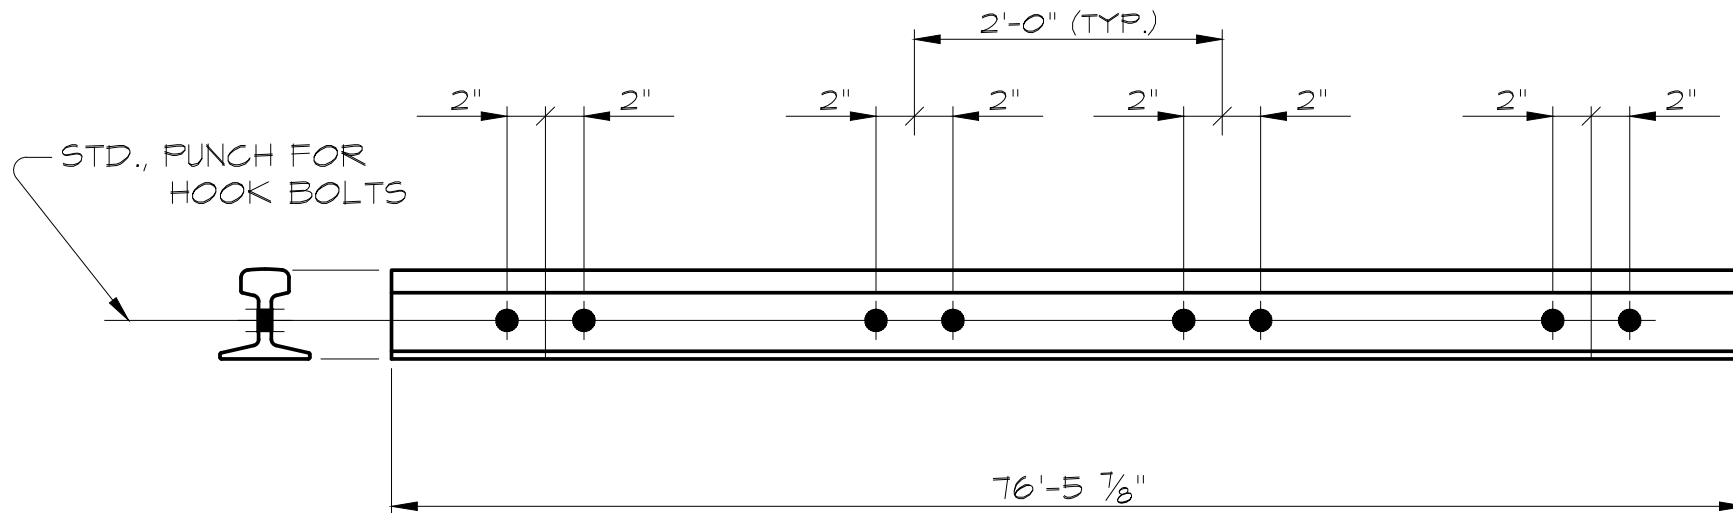



CAD FILE 3591-01BMJ3	PLOTTING SCALE 1 = 1	SHEET NO. J3	JOB NO. 3591-01
DRAWN MLR	DATE 03/18/24	REVISION	
CHECKED VR	DATE 03/19/24	PHASE-II	

QTY. RECIEVED	ITEM	QTY.	MARK	DESCRIPTION	
	1			~ ACCESSORIES ~	PER SPECS.
	2				
	3	ONE	A	Top Running, Double Girder, Bridge Crane	
	4				
	5	4	B	30706 insulated steel personnel doors	
	6				
	7	ONE	C	18'-0" x 16'-0" insulated rolling steel door	
	8				
	9	4	D	MODEL#SWS3OP24A1010 Wall mount supply fan system	
	10				
	11	3	E	MODEL#SRE3ON00A2003 ROOF-MOUNTED EXHAUST VENTILATOR SYSTEMS	
	12				
	13	ONE	V	Ducting for C-52 Compressor	
	14				
	15	ONE	W	Ducting for C-15 Compressor	
	16				
	17	ONE		"FALL SAFE" DEVICE FOR LADDER (SHOP INSTALLED LADDER)	
	18				
	19	2		D6 32" RH SAFETY GATE	
	20				
	21				
	22	50		180' ROLLS OF 1 1/2" DOUBLE SIDED TAPE (USED FOR INSULATION ATTACHMENT)	
	23			Dyna-Flash (Zipper) for Sq. tube (#303), up to 5" sq.	
	24			Dyna-Flash (Zipper) for Sq. tube (#515), up to 10" sq.	
	25			RETROFIT DEKTITES (2"- 7 1/4")	
	26			RETROFIT DEKTITES (3 1/4"- 10")	
	27				



CAD FILE 3591-01BMJ4	PLOTTING SCALE 1 = 1	SHEET NO. J4	JOB NO. 3591-01
DRAWN PSK	DATE 02/19/24	REVISION	
CHECKED BNB	DATE 02/19/24	PHASE-II	

QTY. RECIEVED	ITEM	QTY.	MARK	DESCRIPTION	
	1			~ ACCESSORIES ~	PER SPECS.
	2				
	3				
	4				
	5				
	6				
	7				
	8				
	9				
	10				
	11				
	12				
	13				
	14				
	15	ONE	ROLL	12" WIDE EPDM - 50'-0" ROLL	
	16				
	17	ONE LOT		ROOF SNOW RETENTION SYSTEM	
	18			POLAR-BLOX FOR 7.2 RIBS (AT 2'-4 3/4" SPACING)	
	19			POLAR-BLOX FOR R (AT 1'-0" SPACING)	
	20			TUBES OF SURE BOND; EVER SEALANT SB-190 ADHESIVE	
	21			FOR SNOW JAX (8 for R SNOW JAX PER TUBE USE)	
	22			FOR SNOW JAX (20 for 7.2 rib SNOW JAX PER TUBE USE)	
	23				
	24				
	25				
	26				
	27				



CAD FILE 3591-01BMKI	PLOTTING SCALE 1 = 1	SHEET NO. KI	JOB NO. 3591-01
DRAWN MLR	DATE 03/18/24	REVISION	
CHECKED VR	DATE 03/19/24	PHASE-II	

QTY. RECIEVED	ITEM	QTY.	MARK	DESCRIPTION Title Packing List
	1			INSULATION
	2			
	3			3" THK., 6.0 PCF DENSITY MINERAL WOOL INSULATION
	4			
	5			
	6			
	7	52	PALLETS	48" x 72" LONG (1639) PIECES
	8			
	9			
	10			
	11			
	12			
	13			
	14			
	15			
	16			
	17			
	18			
	19			
	20			
	21			
	22			
	23			6 1/2 " LONG STICK PINS AT WALLS ONLY (2 PER PIECE, USE ONLY IF REQ'D.)
	24	5000	LIN. FT	42" WIDTH PSK FACING AT SIDEWALL AND ENDWALLS
	25		LIN. FT	54" WIDTH PSK FACING AT SPACING BETWEEN 4'-0"
	26	2000	LIN. FT	66" WIDTH PSK FACING AT SPACING BETWEEN 4'-0"
	27		LIN. FT	78" WIDTH PSK FACING AT PEAK & 3'-0" SPACING